

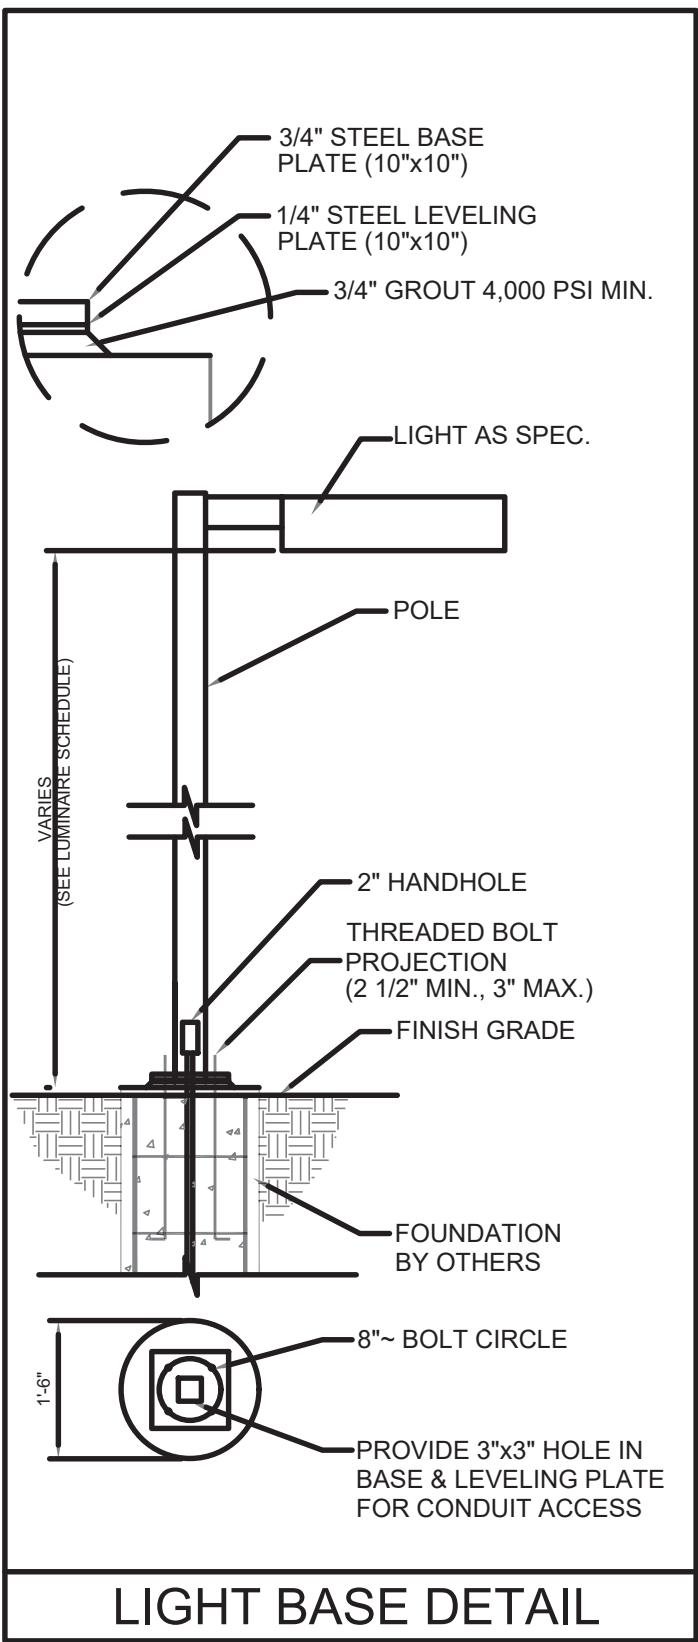


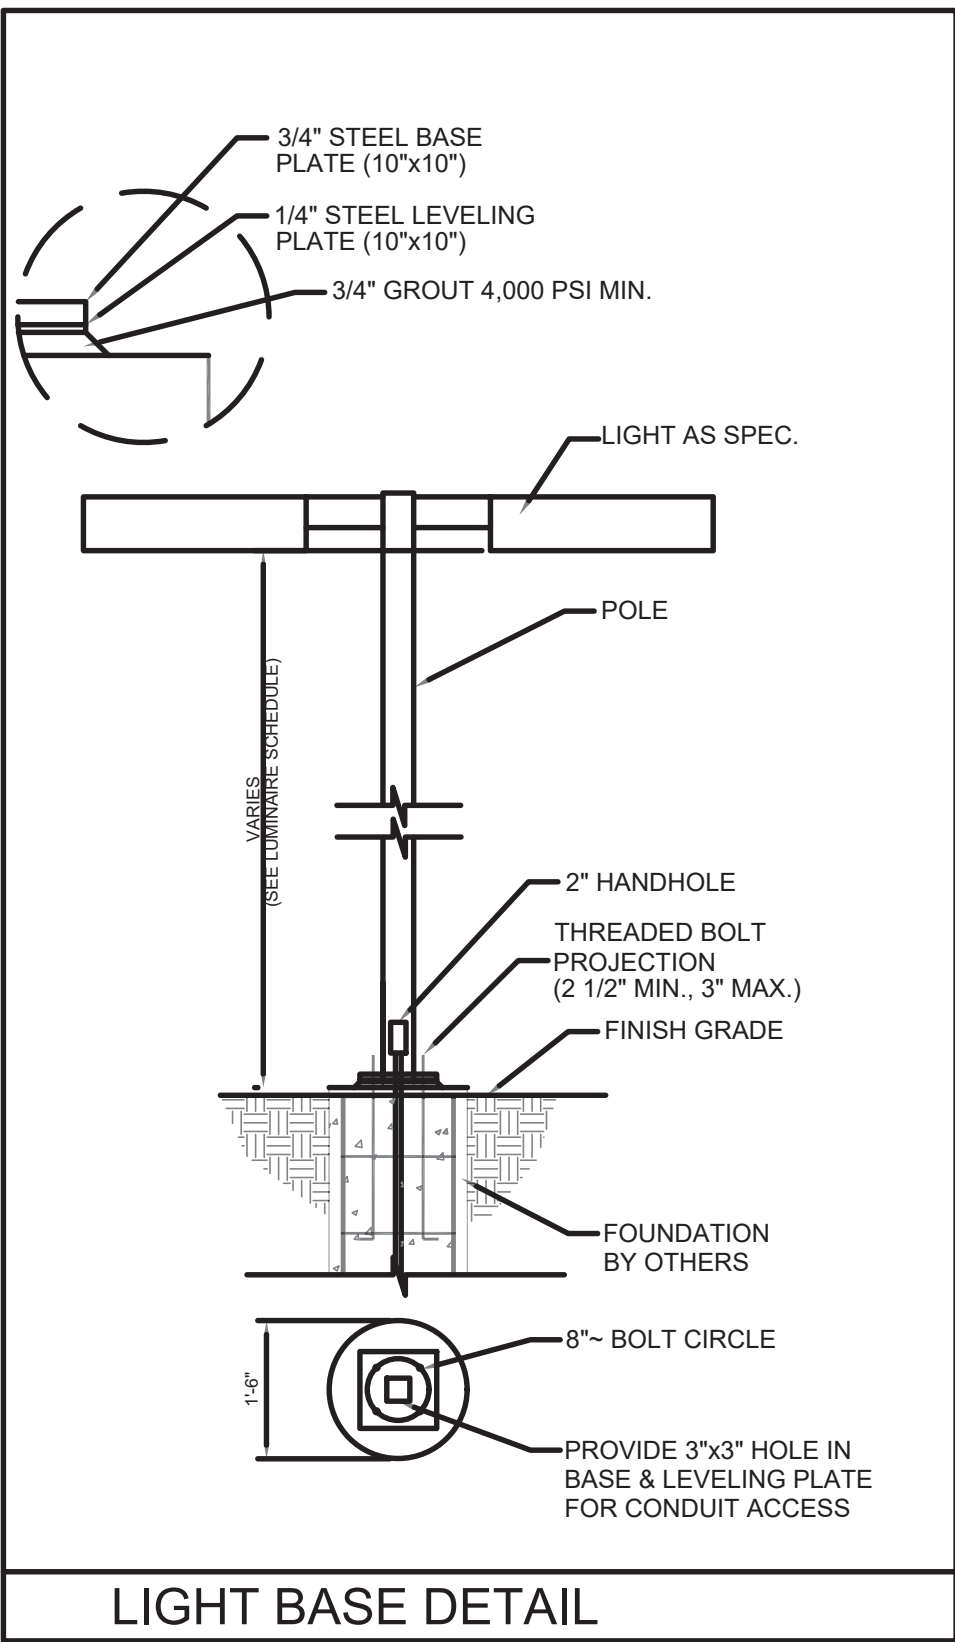

LUMINAIRE SCHEDULE					
SYMBOL	LABEL	QTY.	DESCRIPTION	MTG. HT.	WATTS
	A	1	FLCLED-120W-DOUBLE 90@20°AG- TILT 40	20'	180
	B	3	FLCLED-120W-SINGLE @20°AG - TILT 40	20'	120
	C	8	CWBP LED - WALL PACK 18" - #DC200L56W.50K	15'	56

CALCULATION SUMMARY					
LABEL	AVG.	MAX	MIN.	AVG/MIN	MAX/MIN
OVERALL	2.77	5.0	0.0	N/A	N/A
PARKING	3.78	5.0	0.0	N/A	N/A

FIXTURE-A&B: PARKING LOT LIGHT FIXTURE (1 OR 2 BULBS)

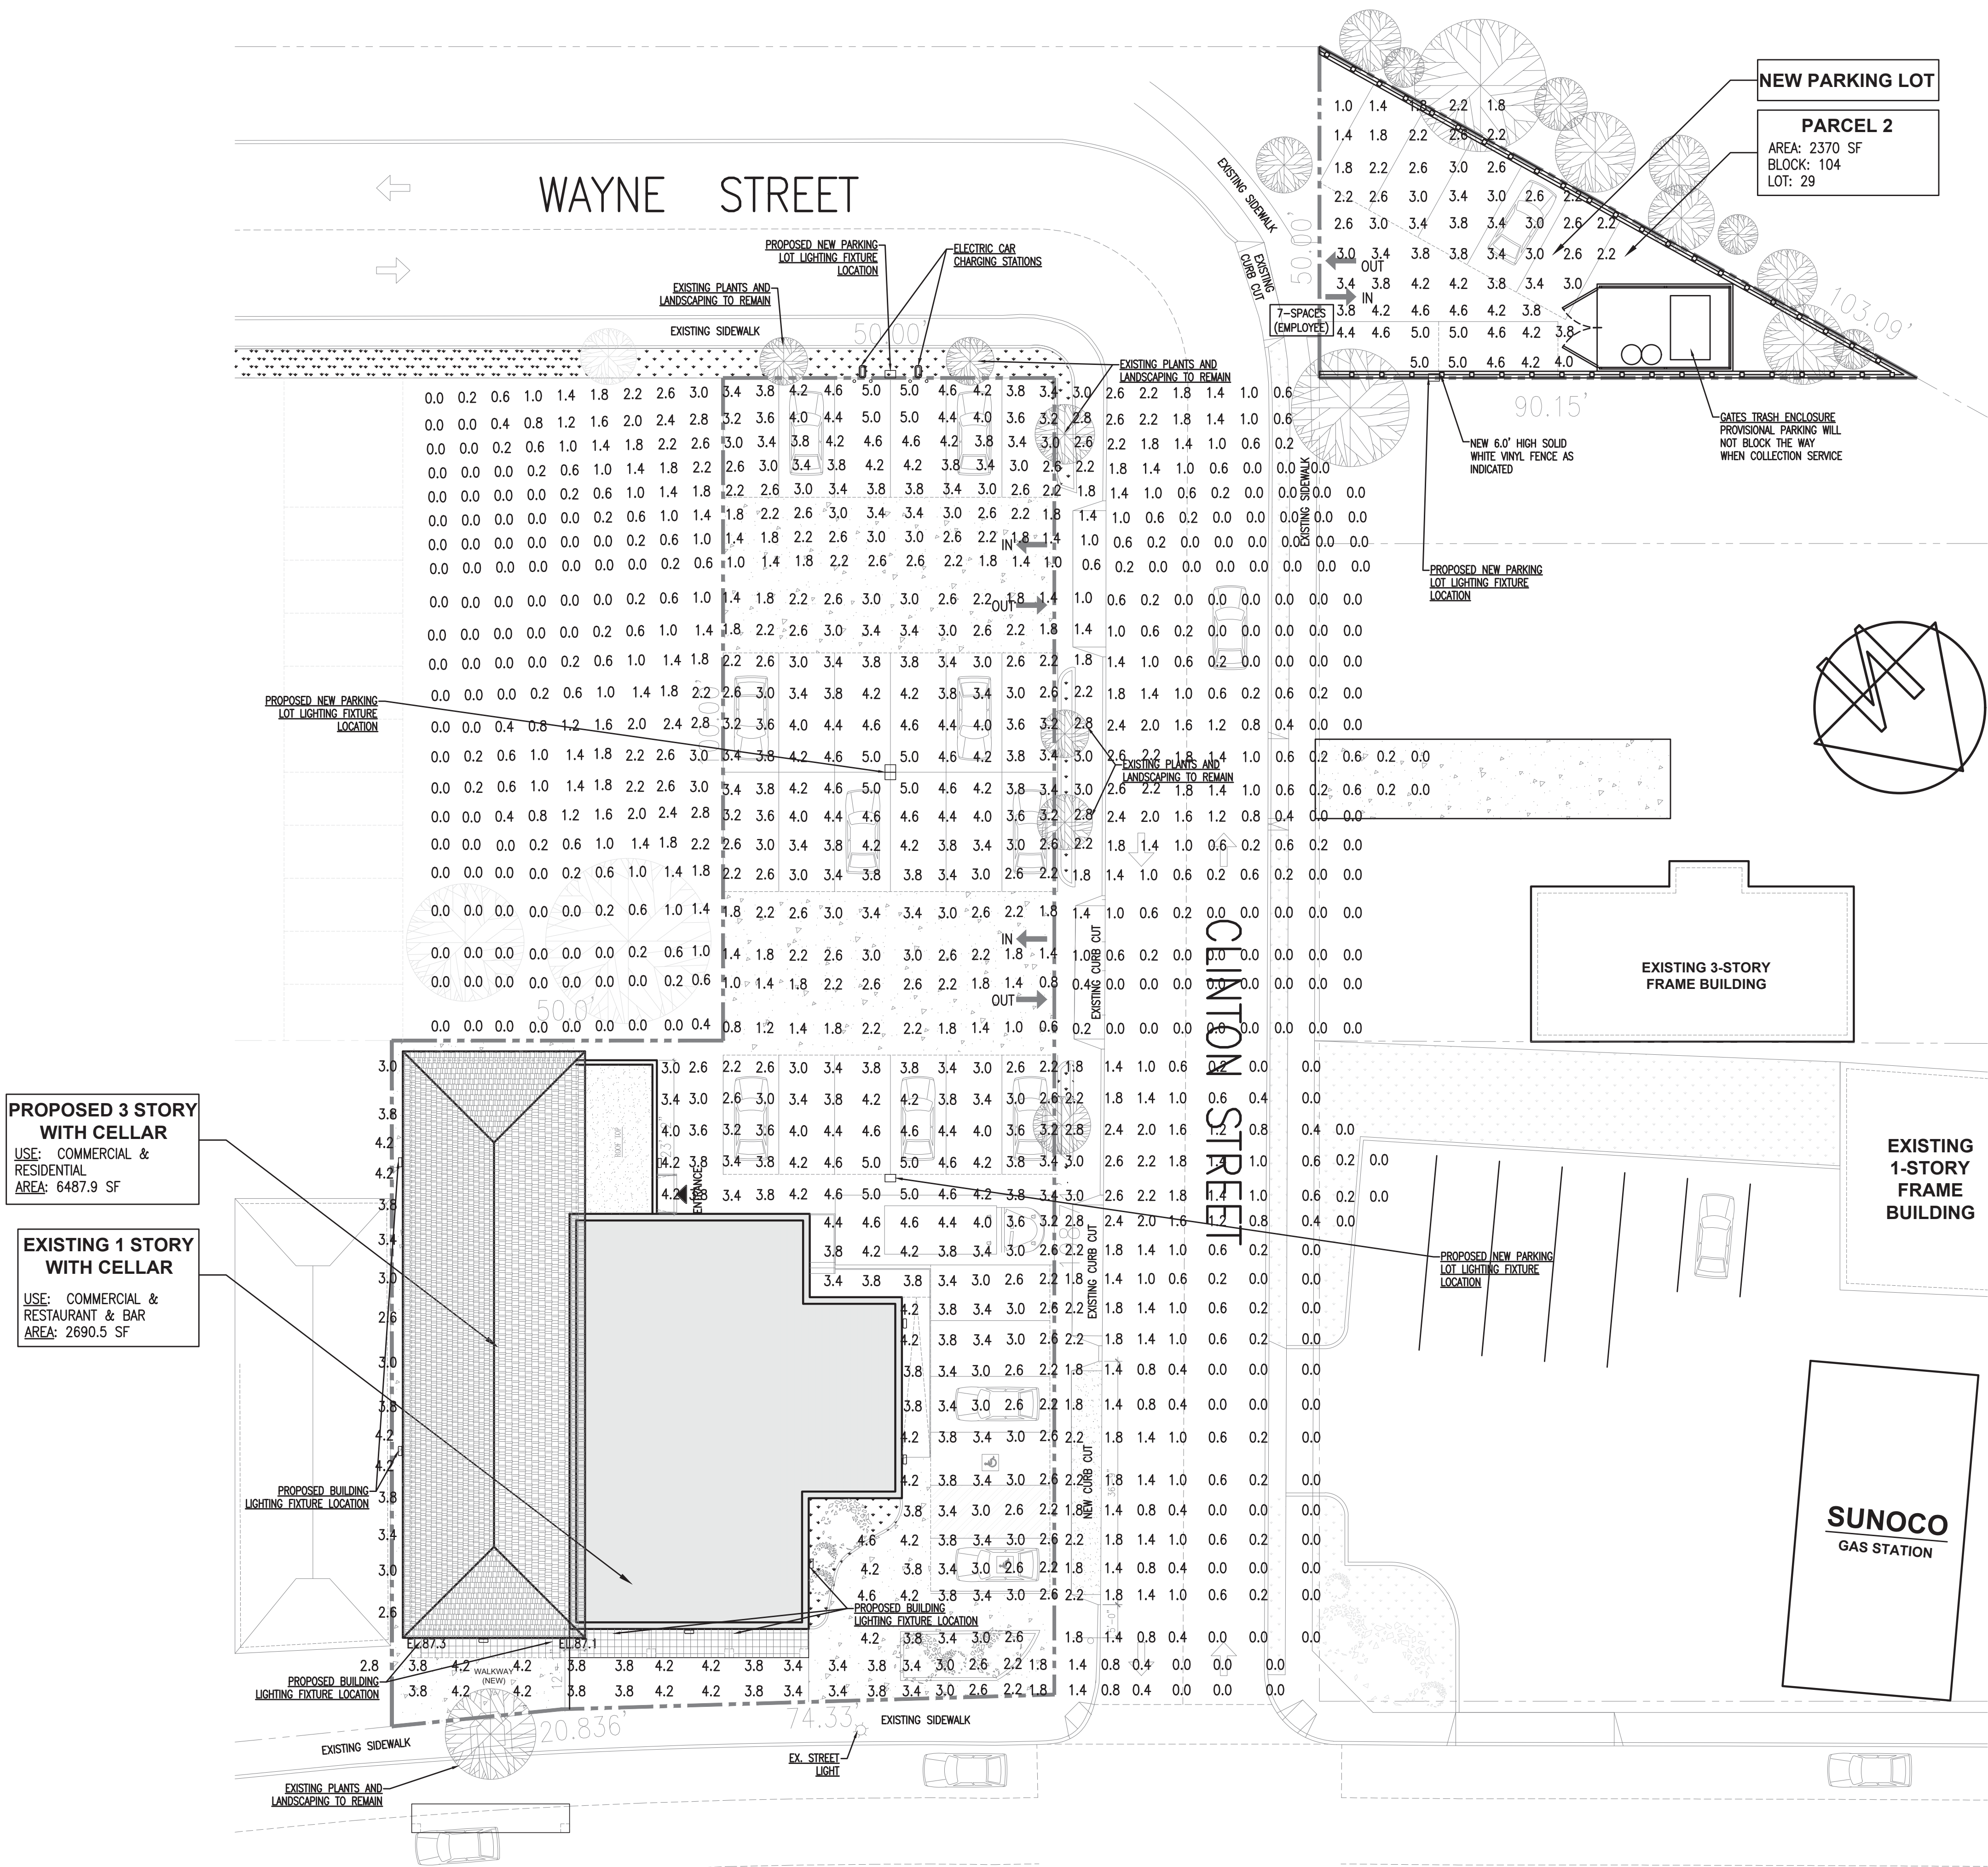

FIXTURE-C: WALL MOUNTED FLOOD LIGHT FIXTURE



AMERILAND BROOK LLC
Architecture, Zoning & Building Code, Interior Design

Address : 30-05 Stratton Street, Queens, NY 11354
Phone : 718.878.6295
Email : ablcny@gmail.com

No.: Date: Revision:

Project Info.:
ENLARGEMENT
352 S RIVERSIDE AVENUE, NY 10520

Drawing Title:
ELECTRICAL SITE LIGHTING PLAN

Drawing No.:
E-001.00

NOTE: Drawing may be printed at reduced scale

Seal / Stamp: Drawn on: 11.20.2023
Signature:



Drawn by: HT
Checked by:

No. of Sheet(s):
1 of 1

Job No. / DOB Sticker:

D.O.B APPROVAL STAMP

SOUTH RIVERSIDE AVENUE
(ALBANY POST ROAD)

LIGHTING PLOT PLAN
SCALE: 1:160