



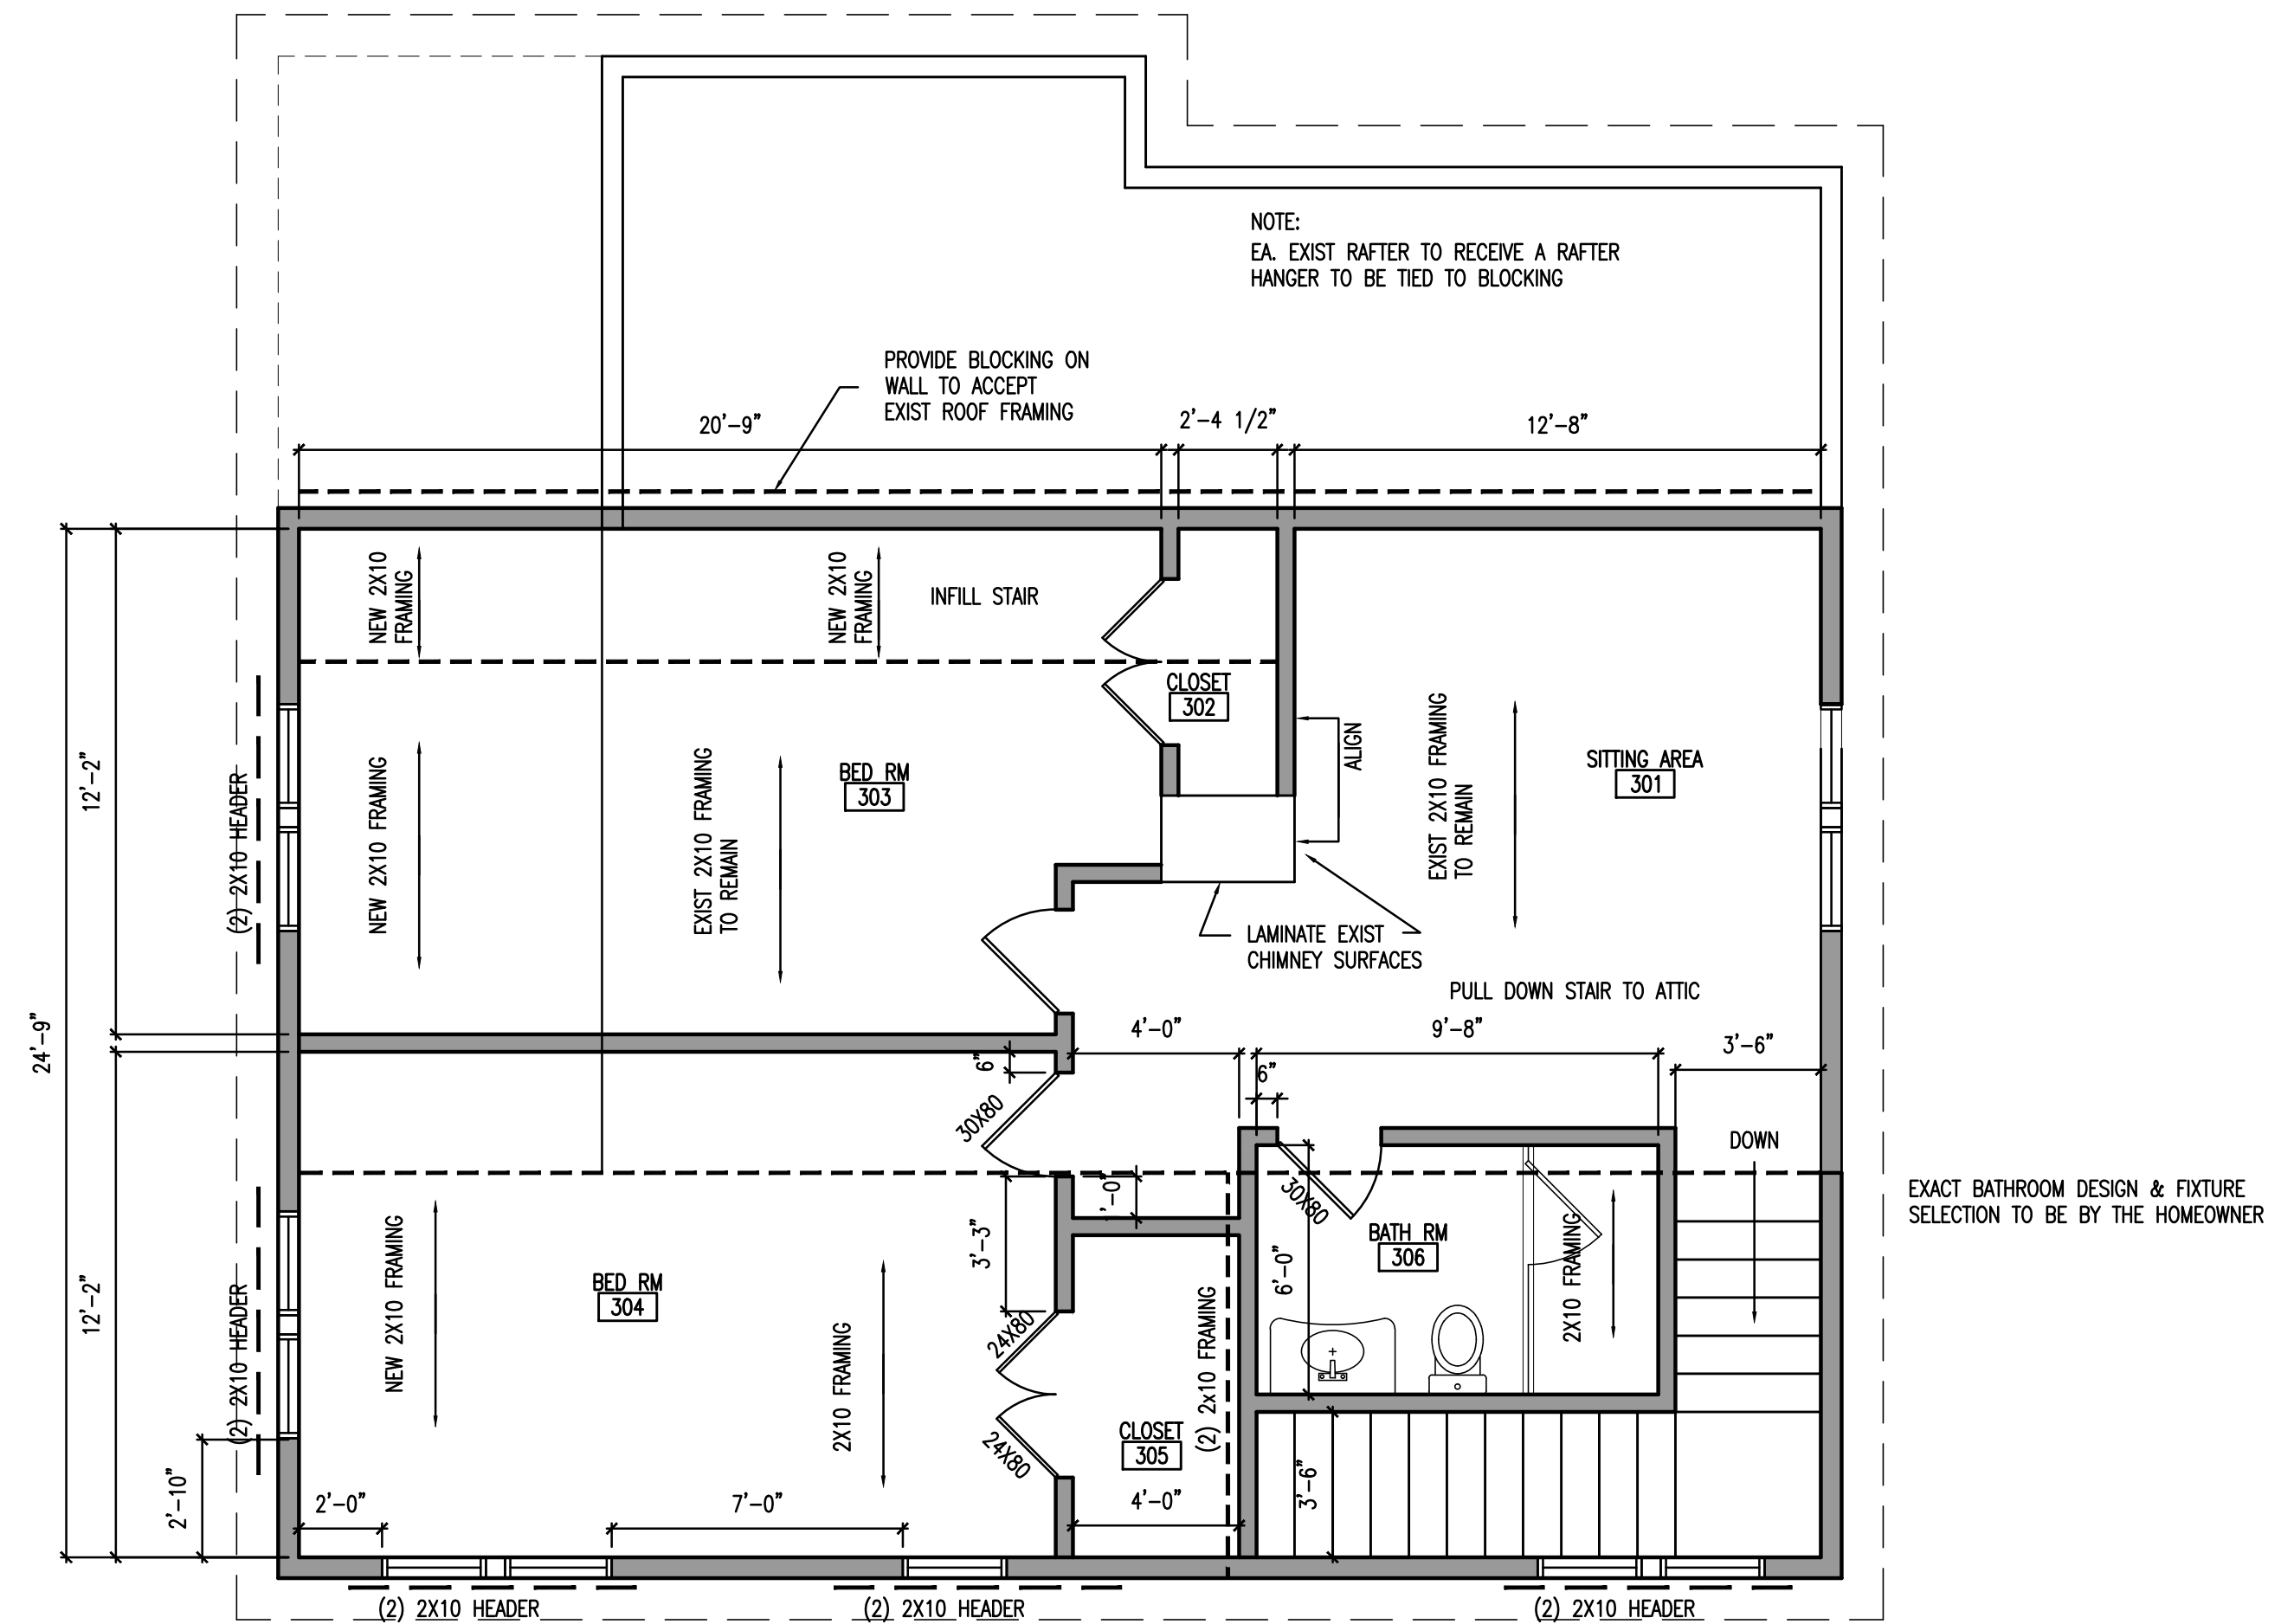

IT IS A VIOLATION FOR ANY PERSON, UNLESS HE OR SHE IS ACTING UNDER THE DIRECTION OF A LICENSED PROFESSIONAL ENGINEER OR LAND SURVEYOR, TO ALTER AN ITEM IN ANY WAY IF AN ITEM BEARING THE SEAL OF AN ENGINEER OR LAND SURVEYOR IS ALTERED. THE ALTERING ENGINEER OR LAND SURVEYOR SHALL AFFIX TO THE ITEM HIS OR HER SEAL AND THE NOTATION "ALTERED BY" FOLLOWED BY HIS OR HER SIGNATURE AND THE DATE OF SUCH ALTERATION, AND A SPECIFIC DESCRIPTION OF THE ALTERATION.

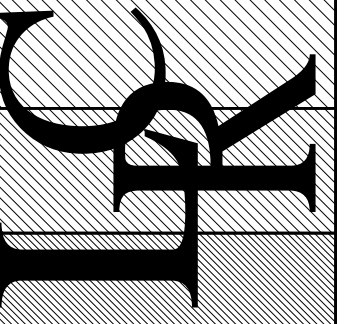

| REVISION | DATE      | ISSUE                   |
|----------|-----------|-------------------------|
|          | 8/01/2023 | ISSUED FOR OWNER REVIEW |
|          | 8/09/2023 | ISSUED FOR FILING       |
|          |           |                         |
|          |           |                         |
|          |           |                         |

PROJECT NAME  
PROPOSED RENOVATION TO THE:  
DEPREZ RESIDENCE  
34 MORNINGSIDE DRIVE  
CROTON-ON-HUDSON, NY 10520

DRAWING TITLE

LIGHTING & POWER PLANS

DRAWING TITLE

4/27/2023

| DATE | AS NOTED |
|------|----------|
|------|----------|

DRAWING NUMBER

A-4