


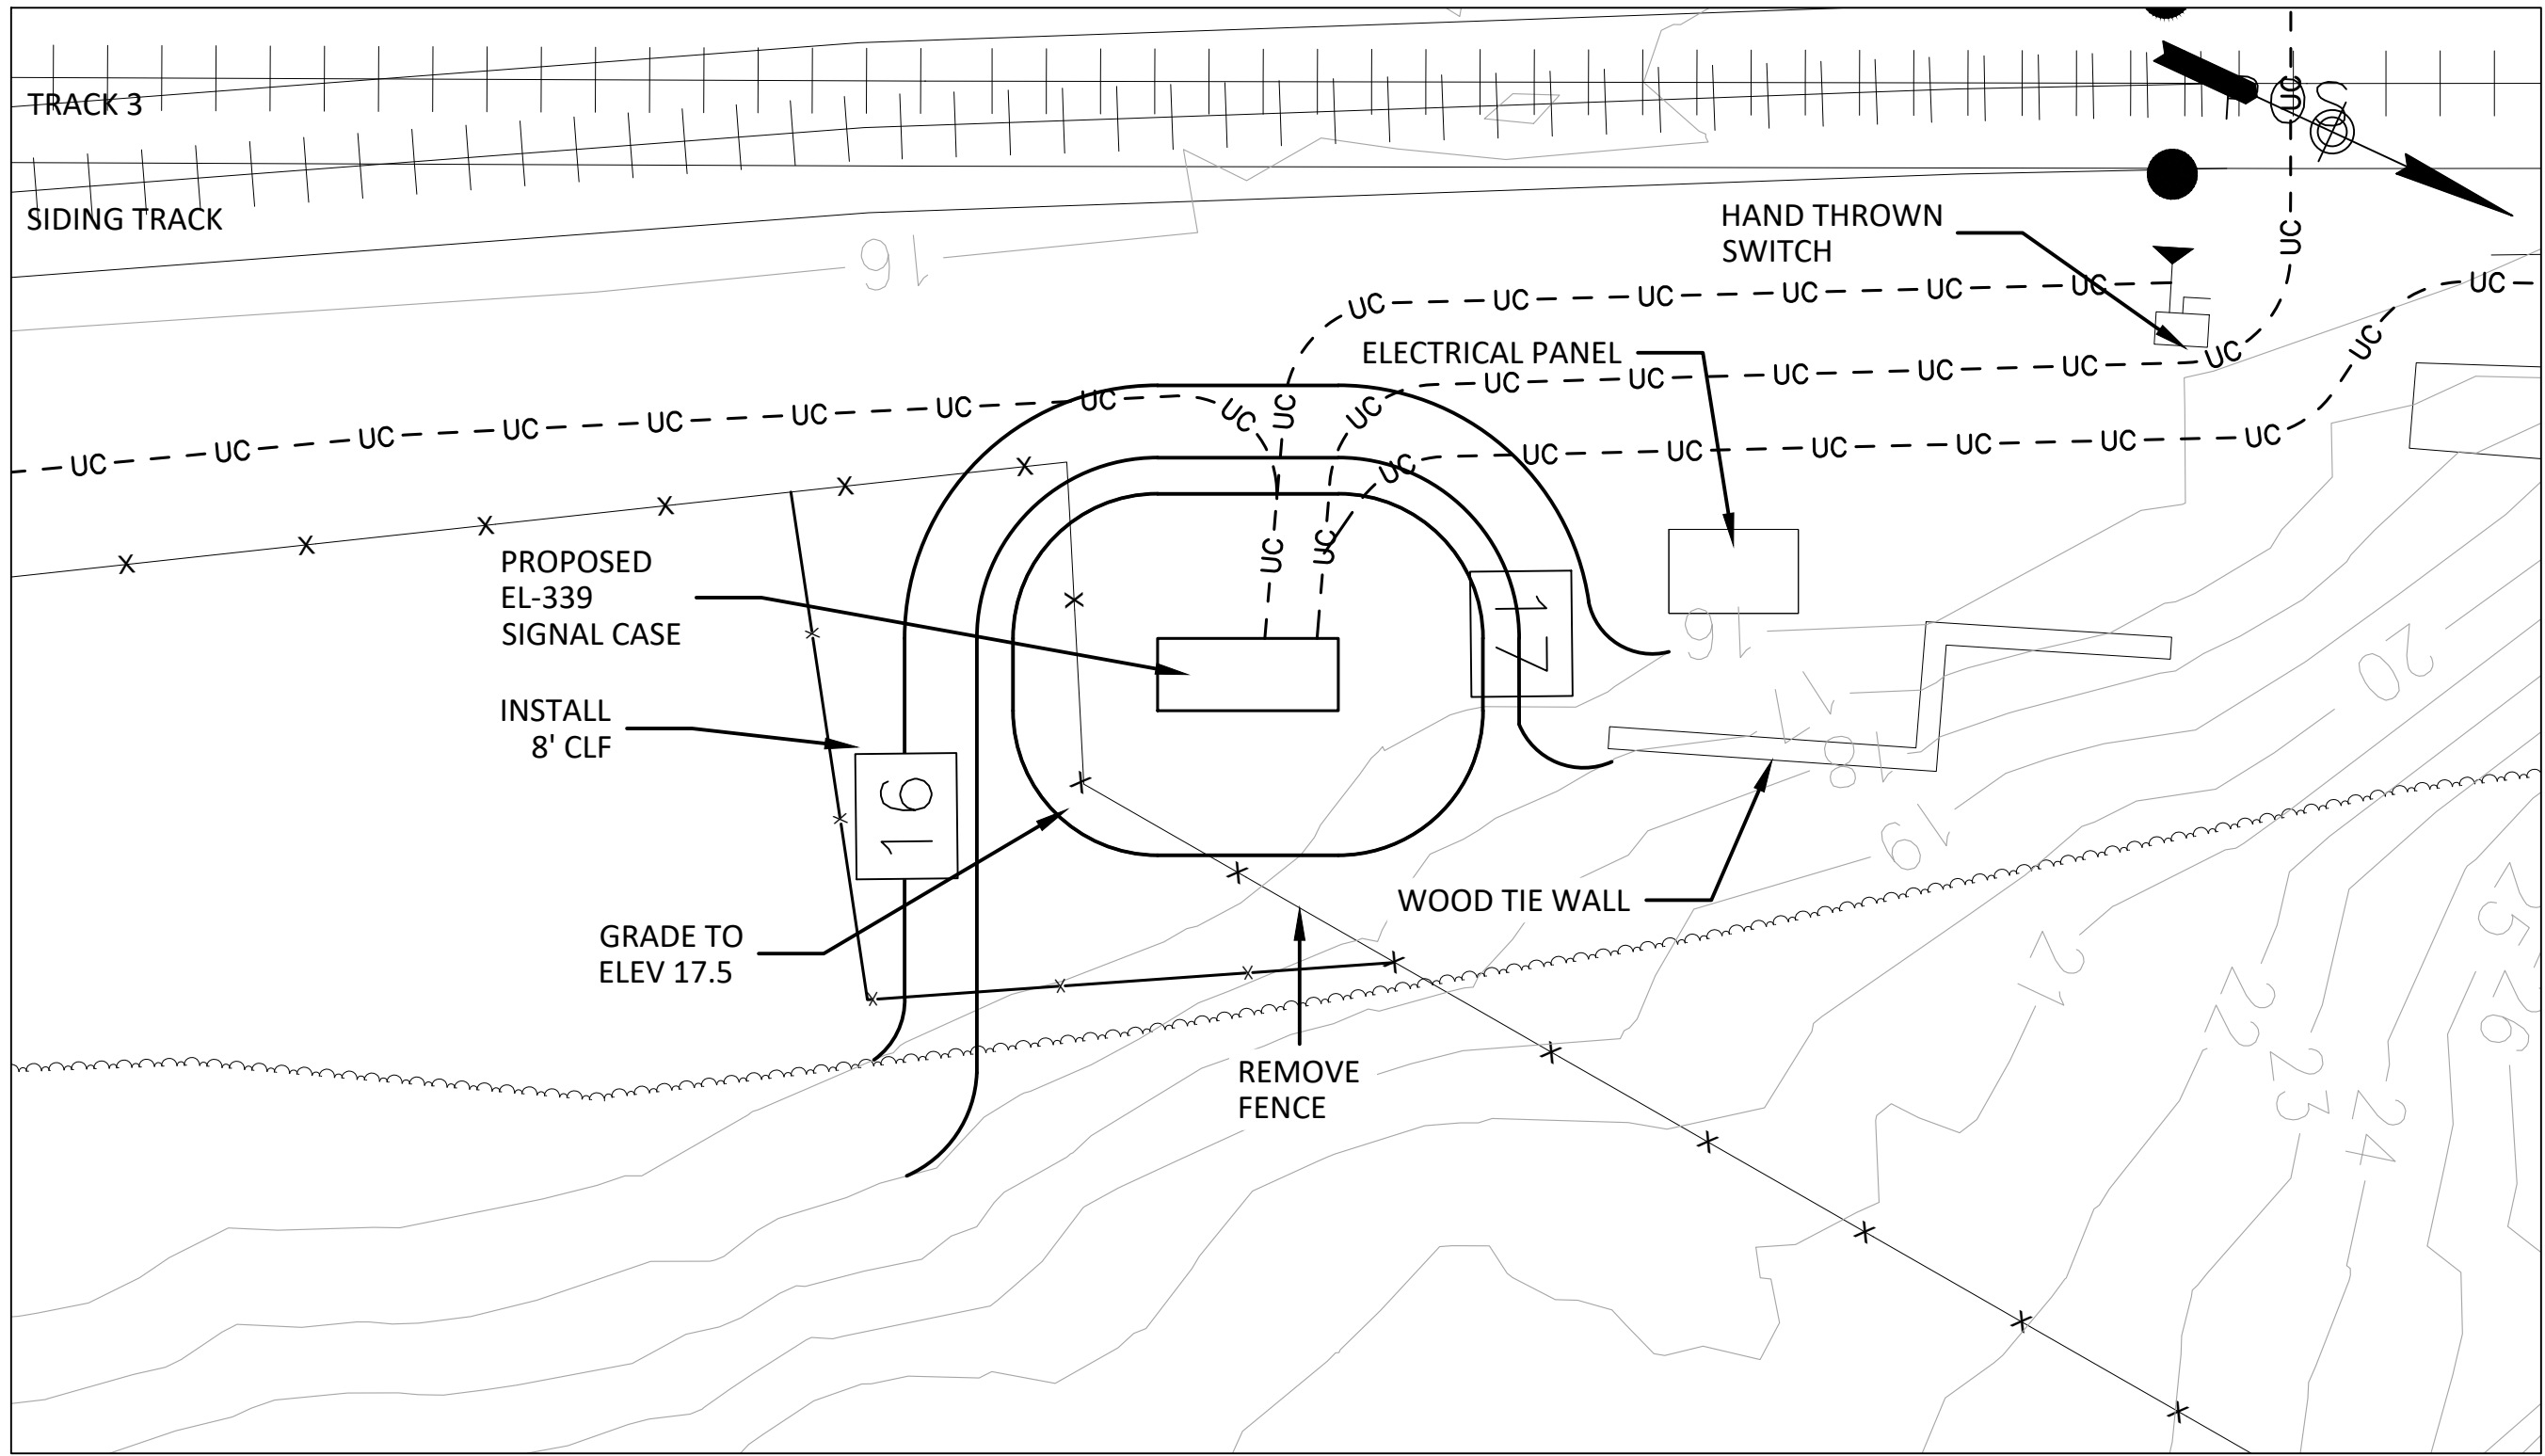


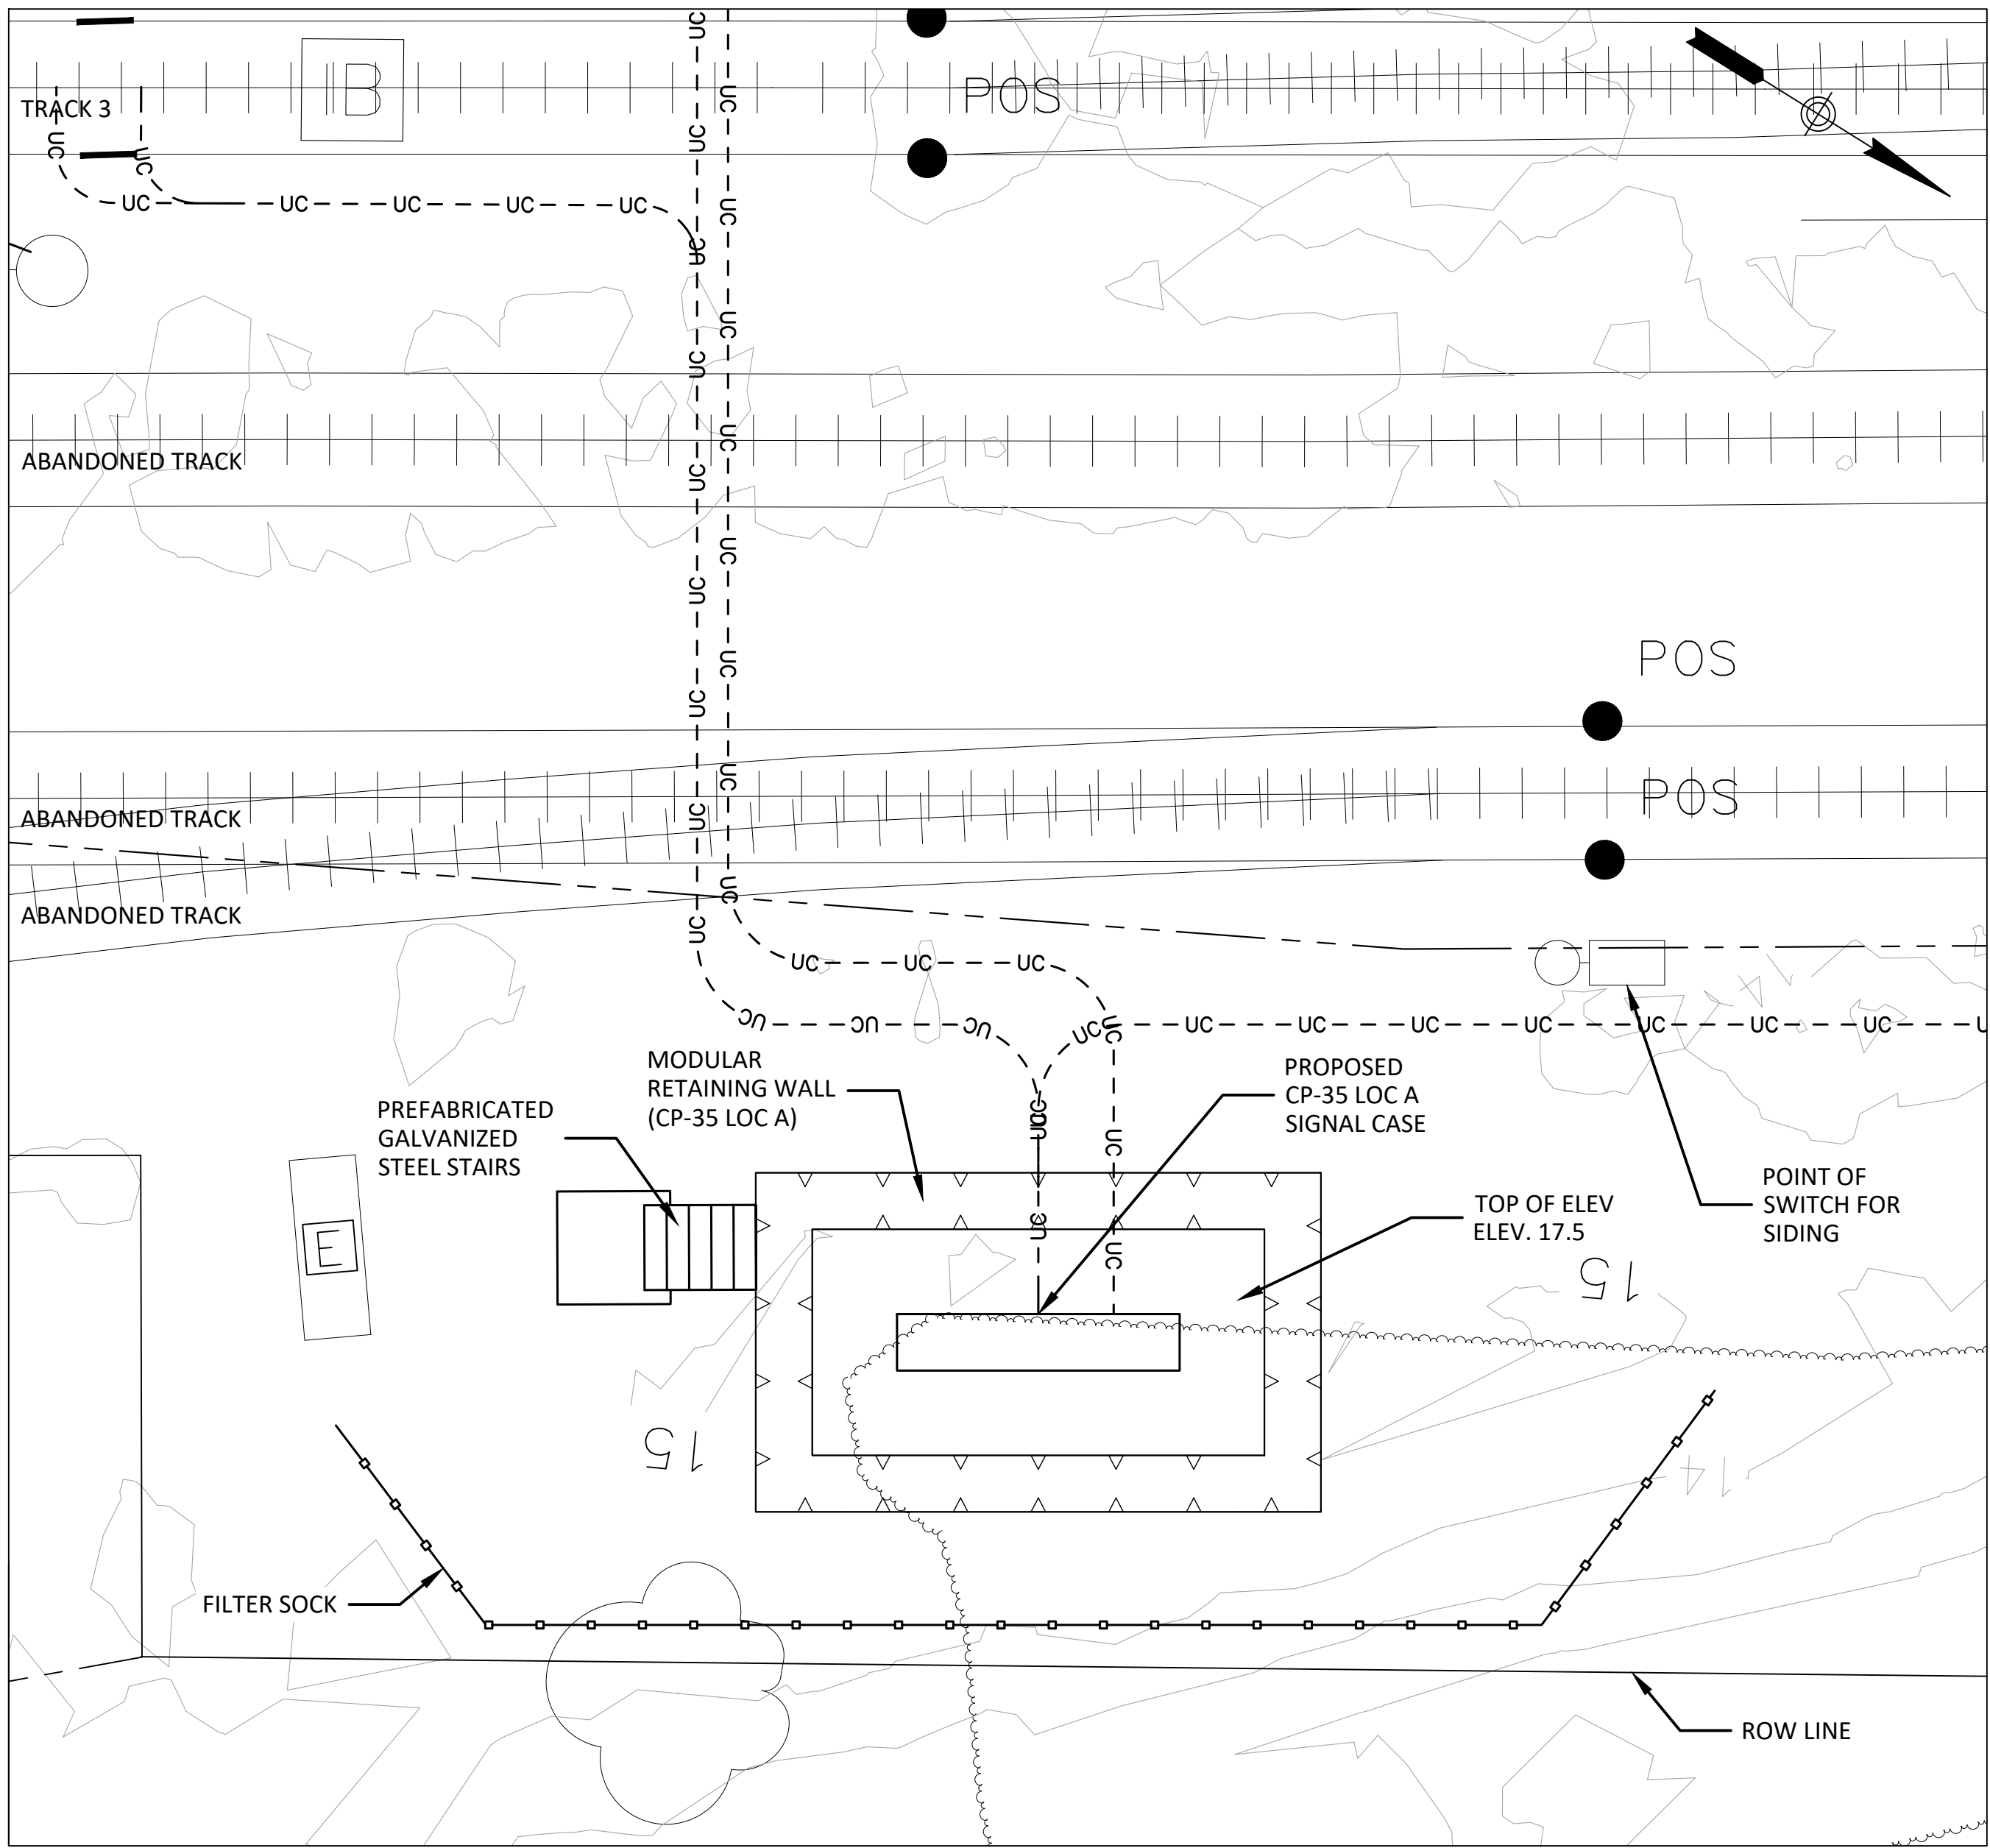


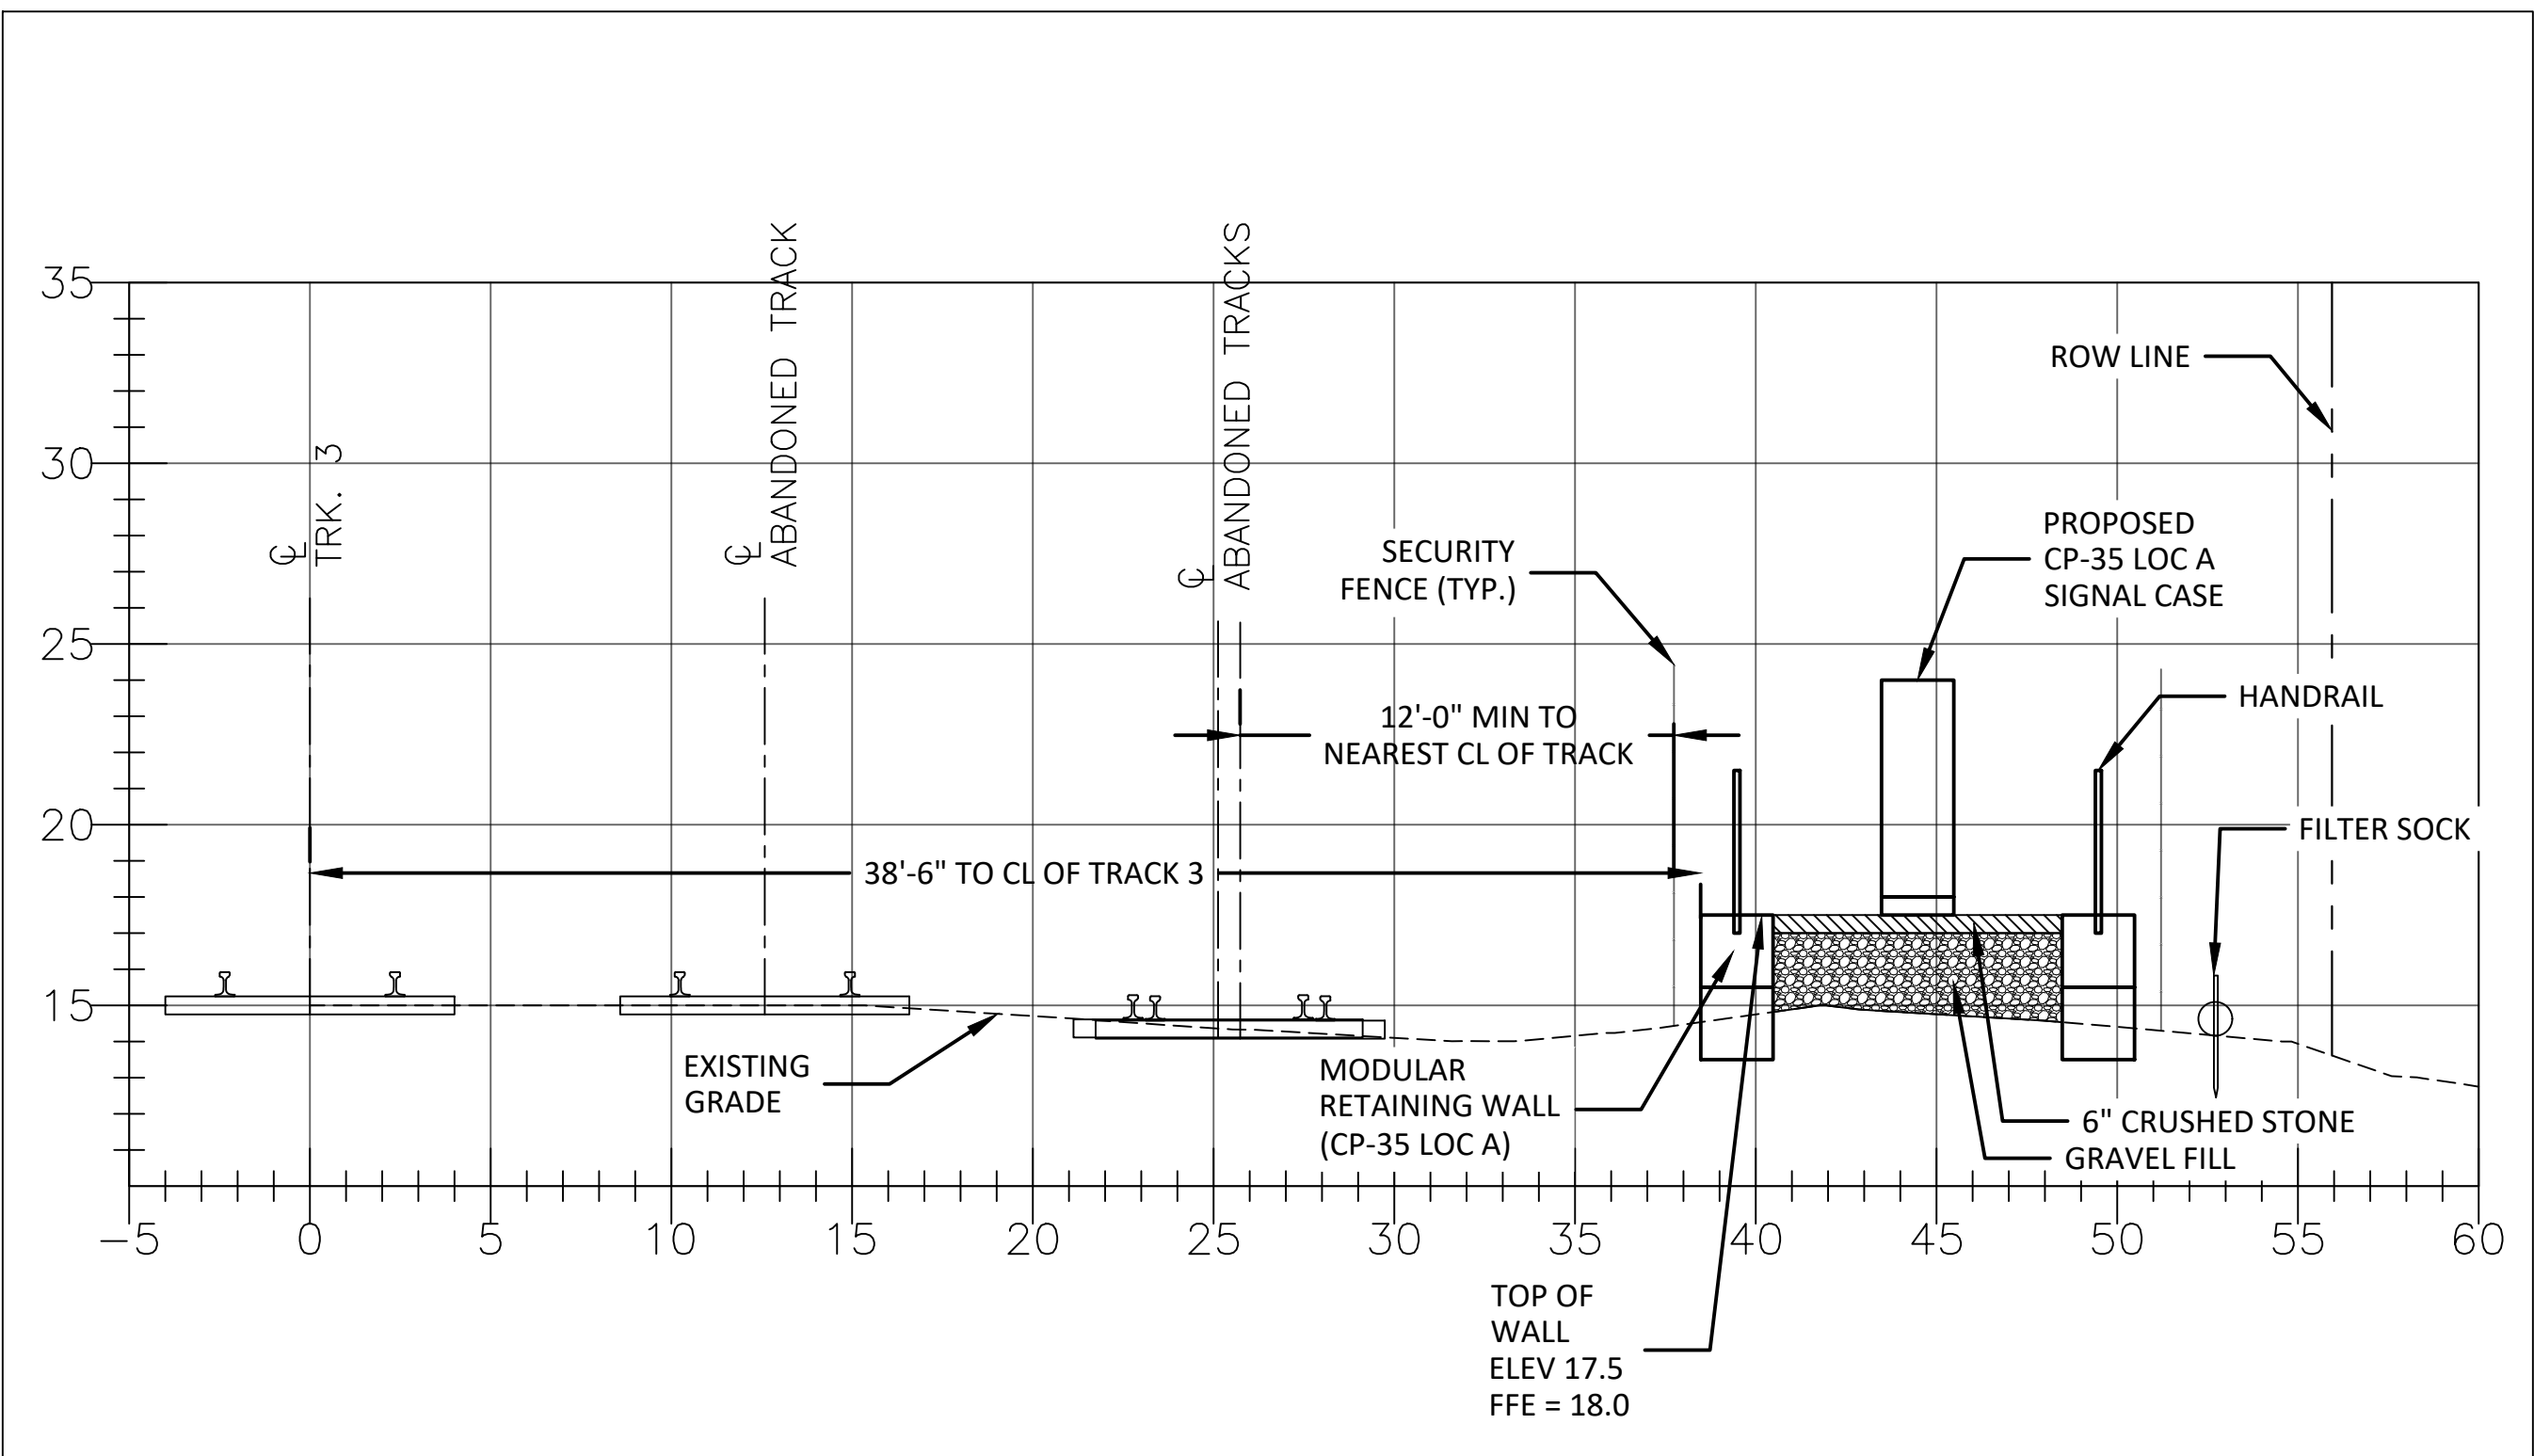

CP-35 LOC A GRADING PLAN VIEW

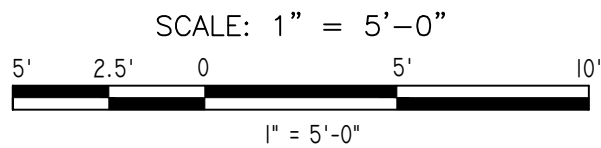

CP-35 LOC A GRADING ELEVATION VIEW

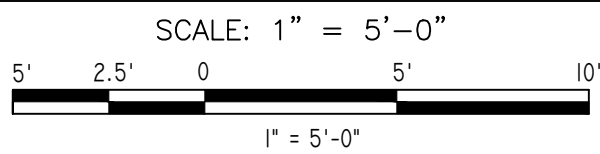

95% SUBMISSION

DISCLAIMER											
IT IS A VIOLATION OF THE PROFESSIONAL LICENSE LAW FOR ANY PERSON TO ALTER THIS DRAWING IN ANY WAY, UNLESS ACTING UNDER THE DIRECTION OF A LICENSED PROFESSIONAL ENGINEER/ARCHITECT AS APPLICABLE. THE ALTERING ENGINEER/ARCHITECT SHALL AFFIX HIS/HER SEAL AND THE NOTATION "ALTERED BY" FOLLOWED BY HIS/HER SIGNATURE AND DATE OF ALTERATION.											
NO.	DATE	MODIFICATION	DRAWN	CHKD.	APPRVD.	NO.	DATE	MODIFICATION	DRAWN	CHKD.	APPRVD.
REVISIONS						REVISIONS					

DESIGNED	J.L.B.
DRAWN	J.T.M.
CHECKED	G.E.
APPROVED	A.E.M.

Gannett Fleming
Transit & Rail Systems


CWA
GANNETT FLEMING/CWA, a joint venture
TWO PENN PLAZA, SUITE 552
380 SEVENTH AVENUE
NEW YORK, NY 10121-0101
PRJ: 059824

Metro-North Railroad
347 MADISON AVENUE
NEW YORK, N.Y. 10017



HUDSON LINE C&S IMPROVEMENTS
EQUIPMENT INSTALLATIONS
MP-32 TO MP-76

CIVIL PLANS
GRADING DETAILS FOR
CP-35 LOC A


CONTRACT NUMBER		39462	
SCALE:	AS SHOWN	DATE:	11/04/2022
DRAWING NUMBER		GRD-102	
SHEET	155	OF	610

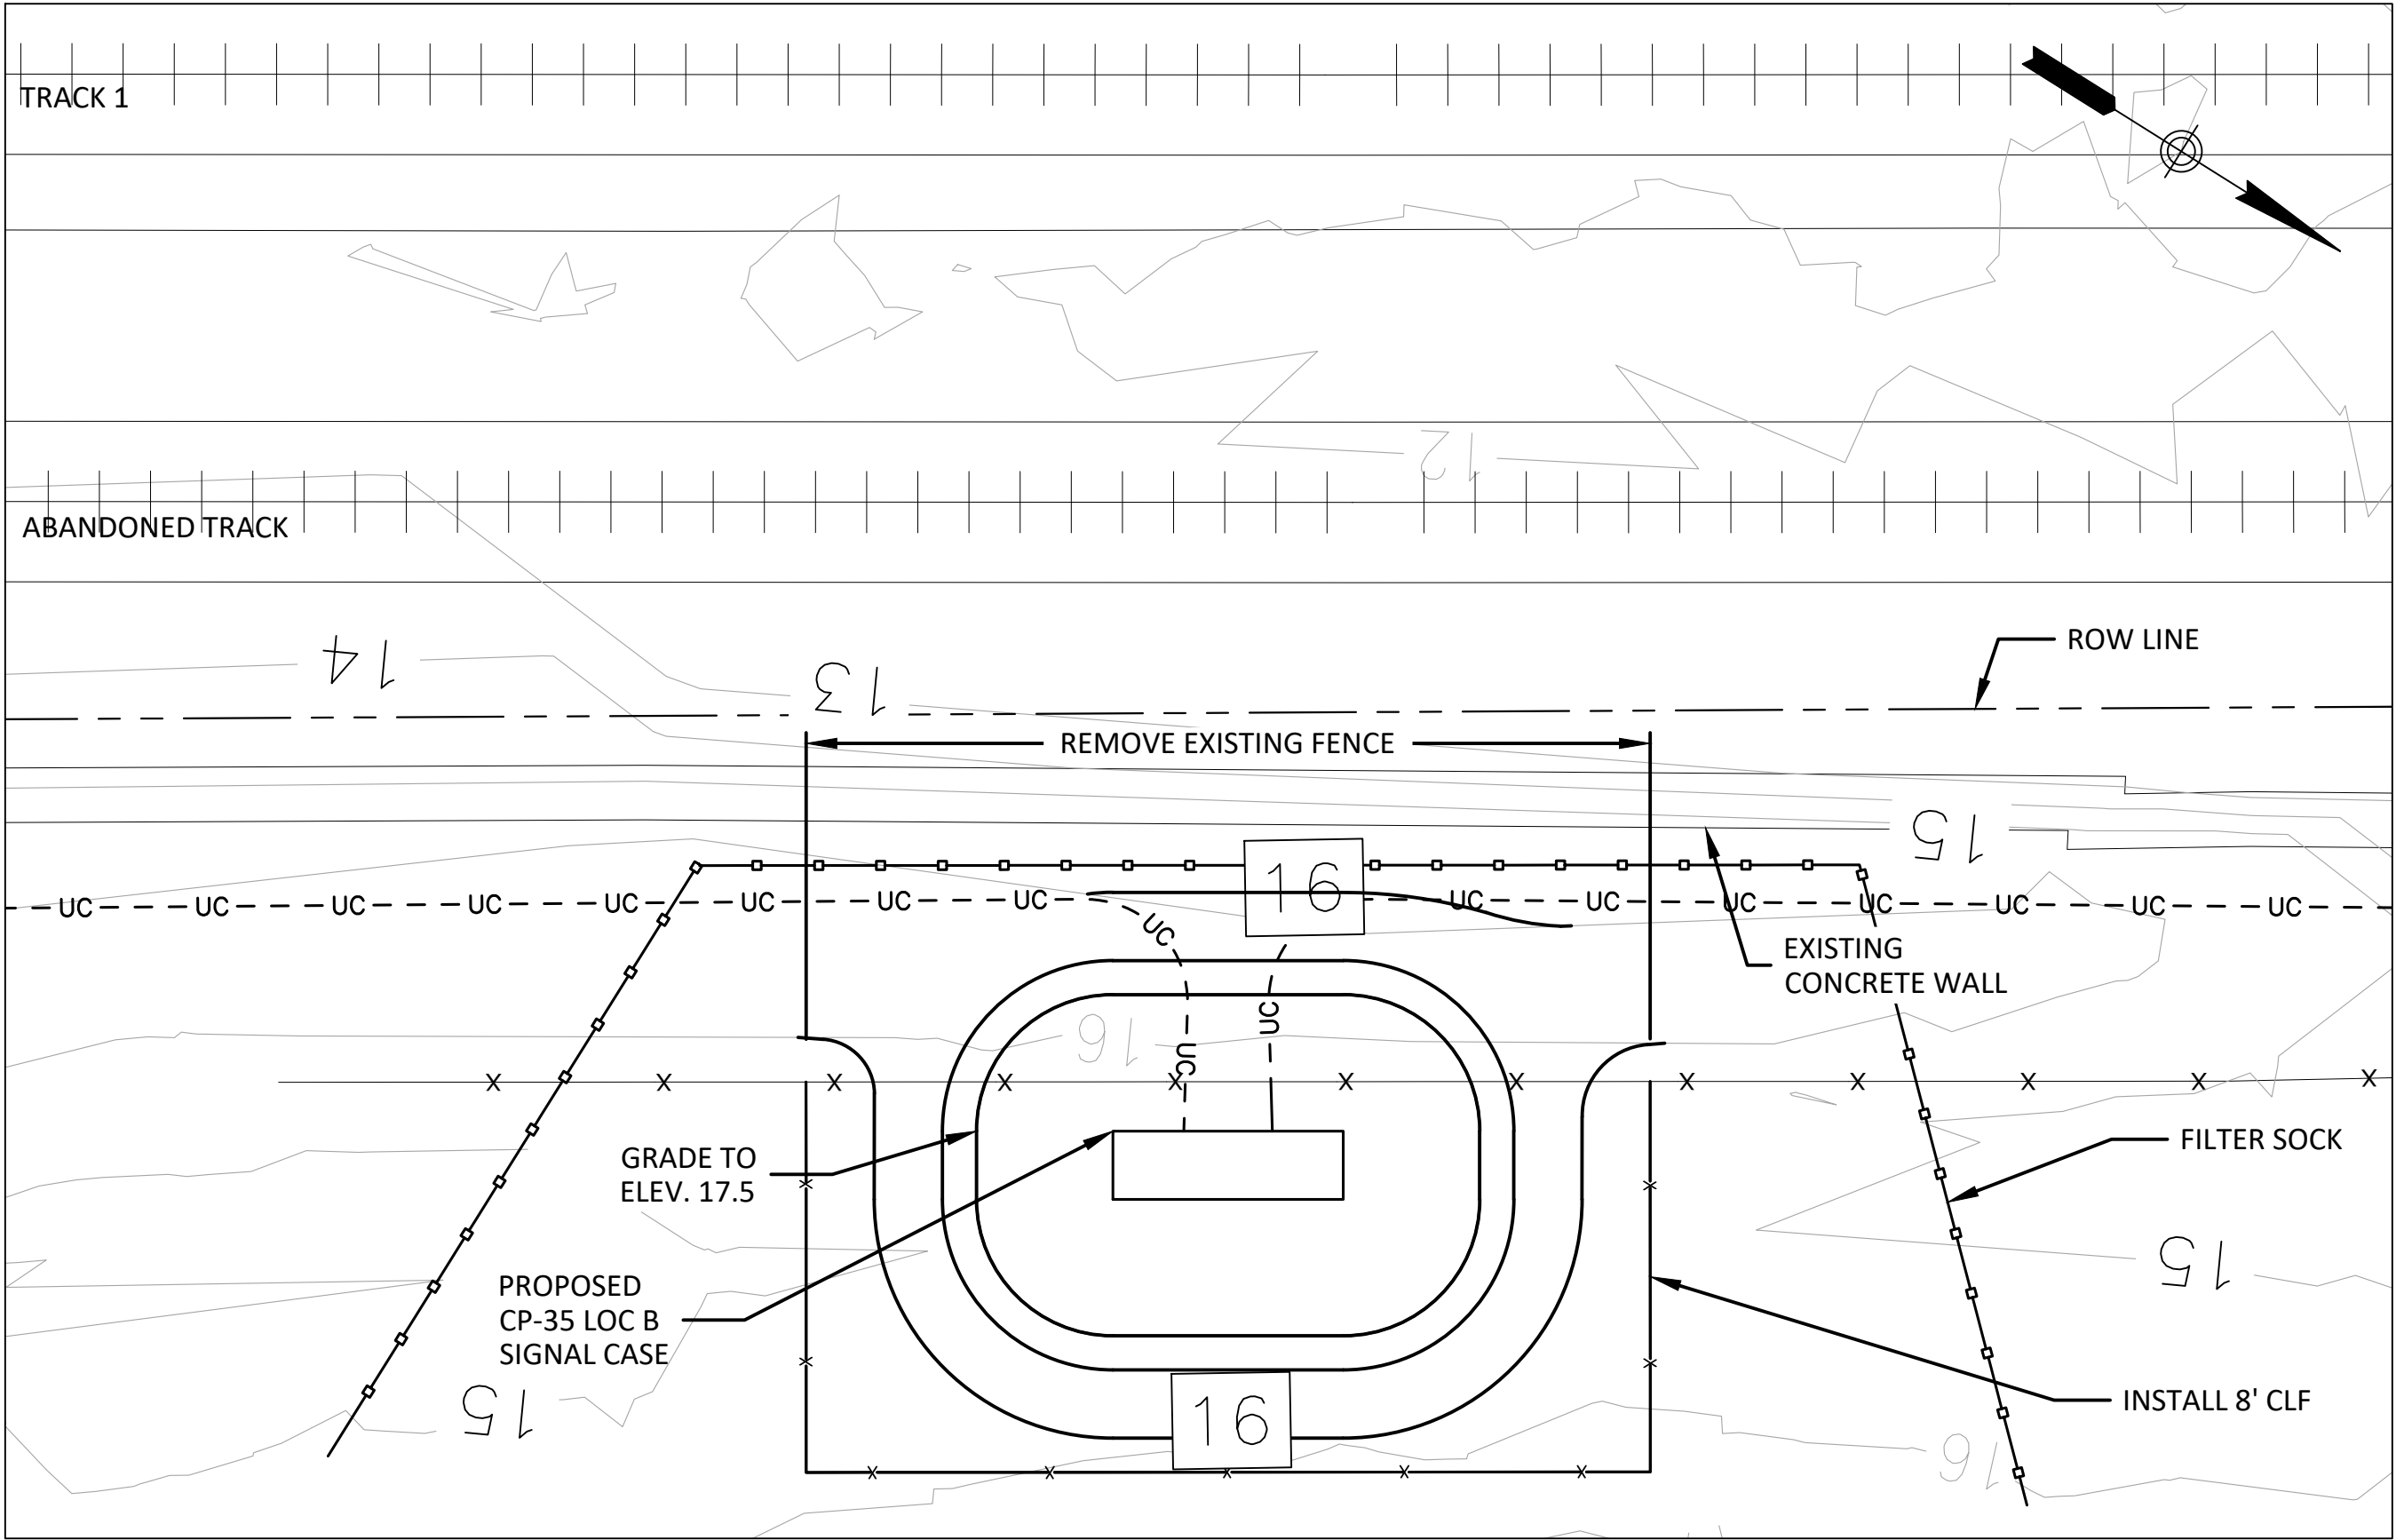

CP-35 LOC B GRADING PLAN VIEW

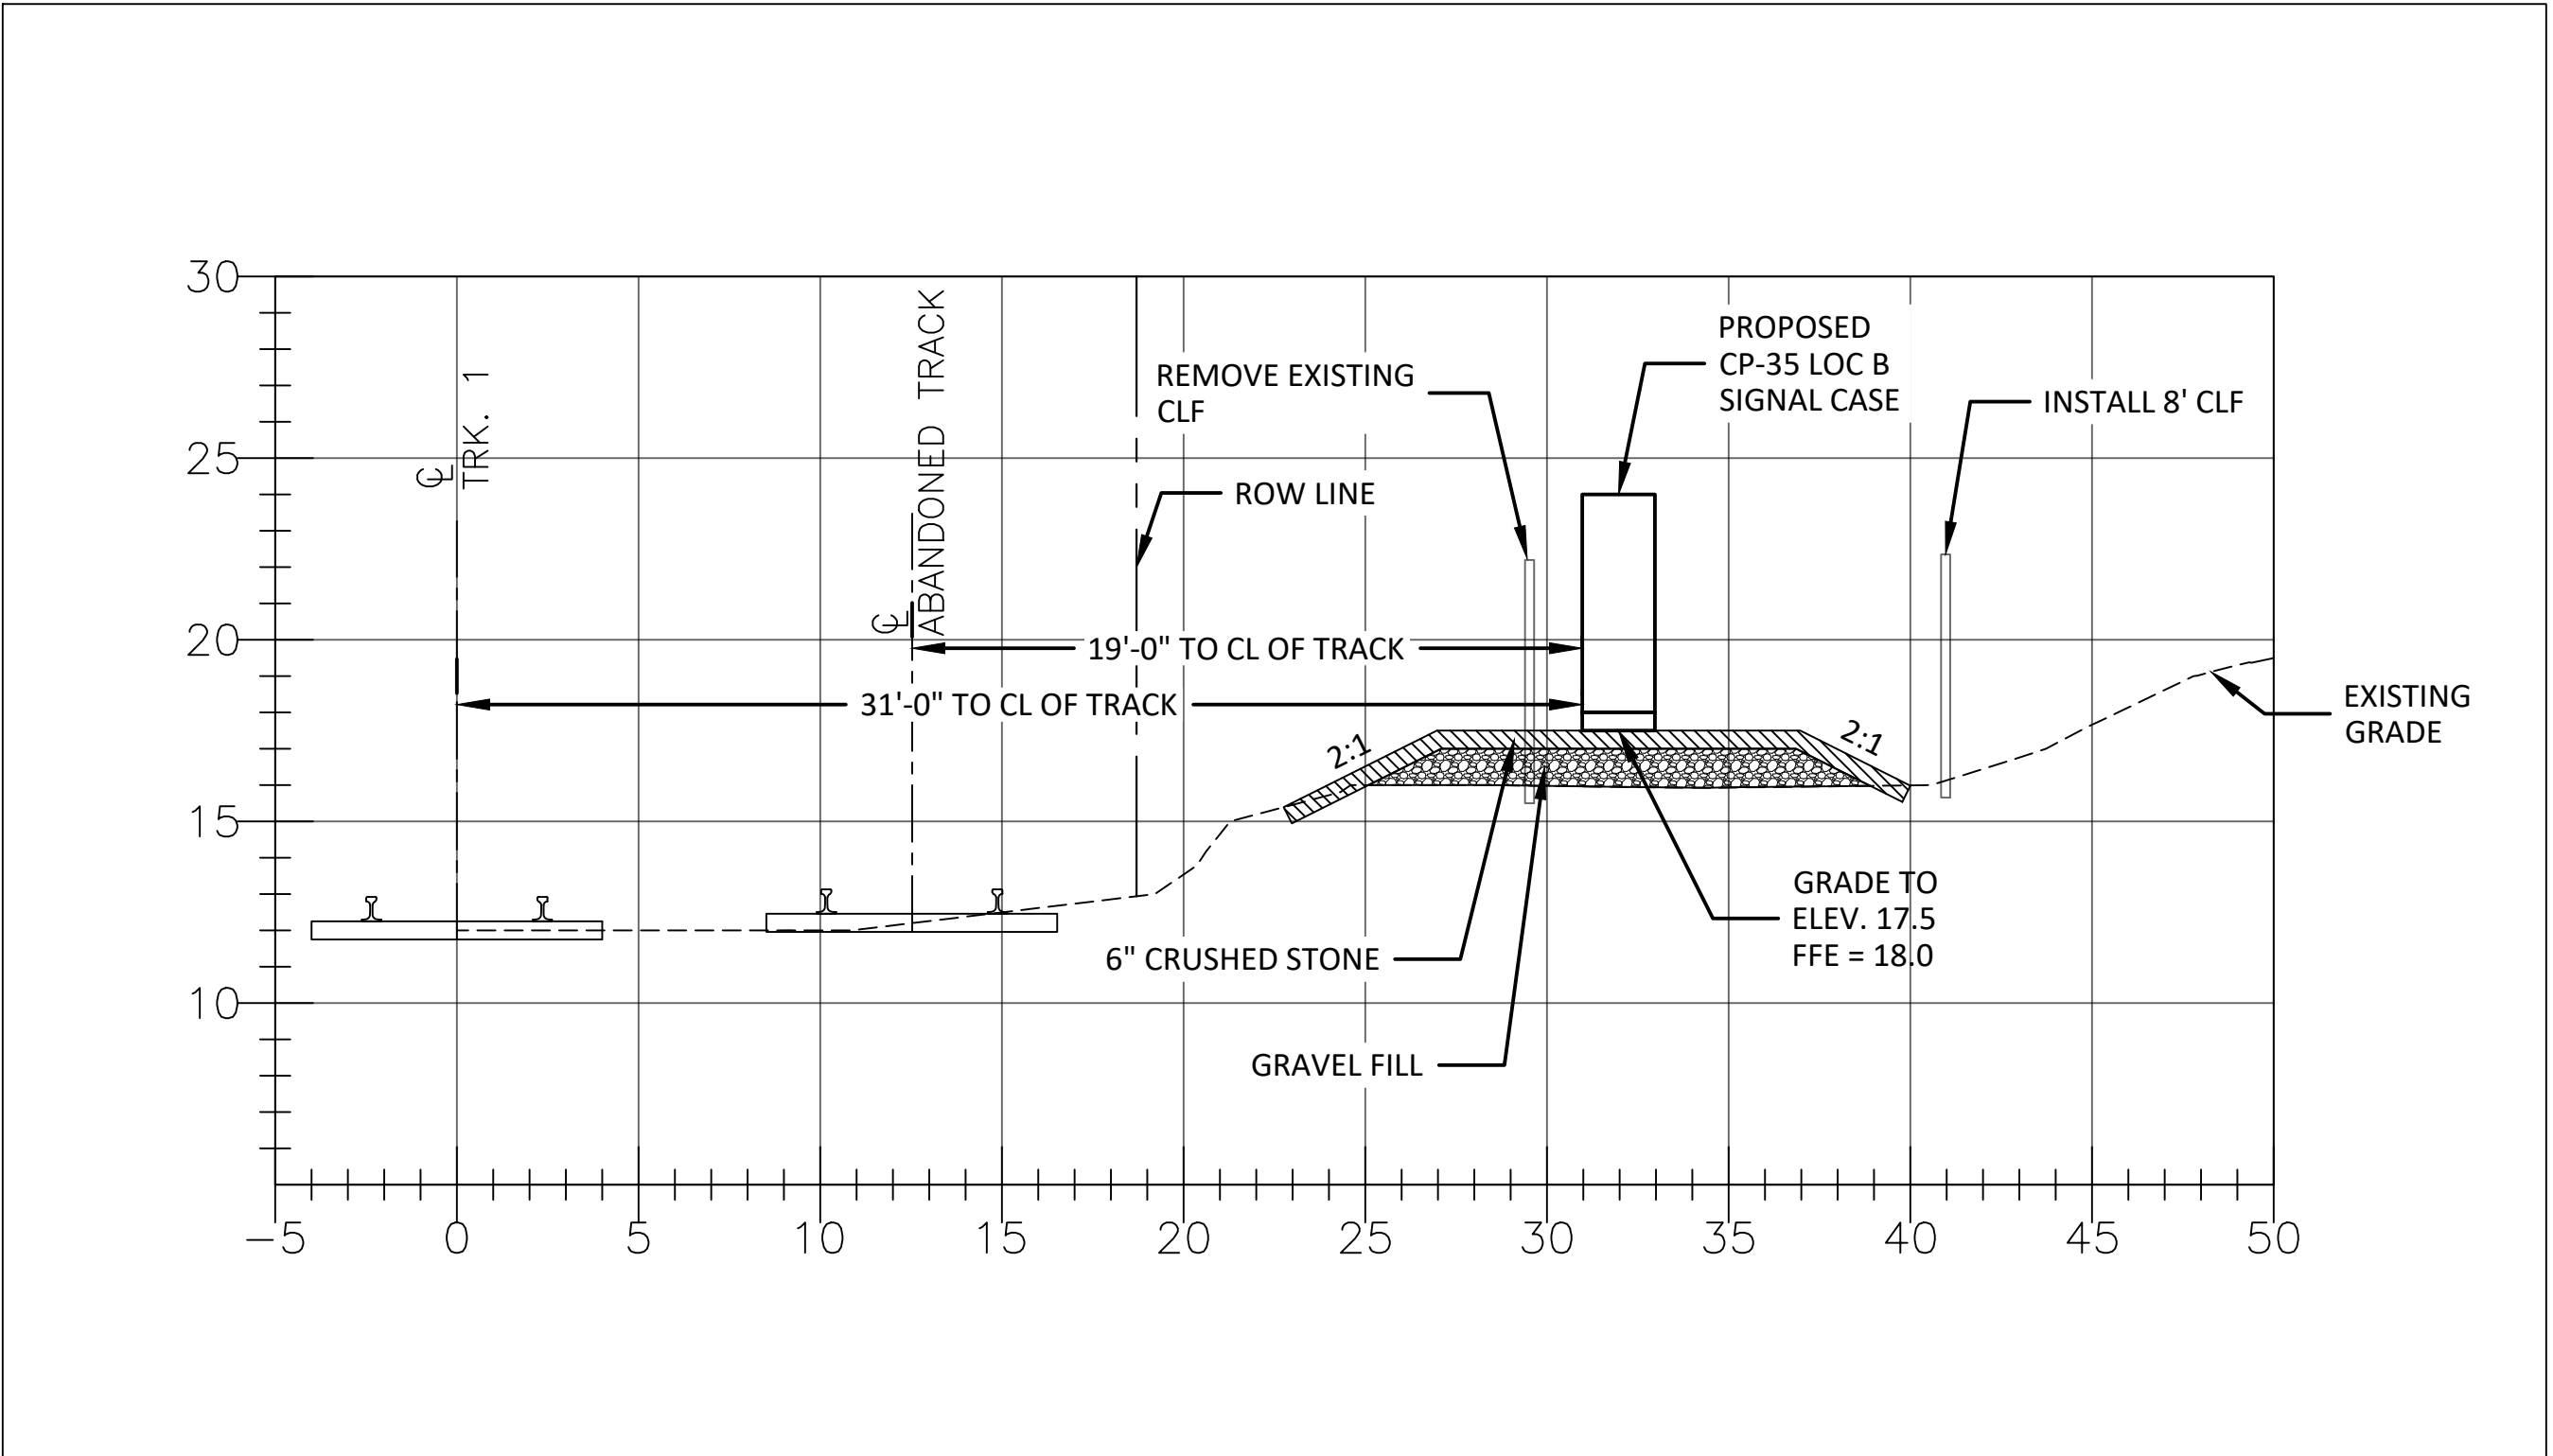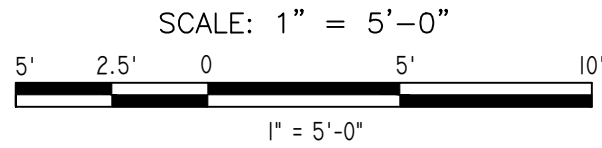

CP-35 LOC B GRADING ELEVATION VIEW

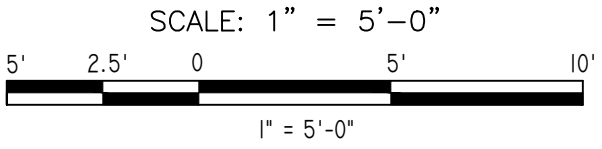

95% SUBMISSION

NO.				DATE				MODIFICATION				DRAWN				CHKD.				APPRVD.				NO.				DATE				MODIFICATION				DRAWN				CHKD.				APPRVD.			
REVISIONS																																															

DISCLAIMER

IT IS A VIOLATION OF THE PROFESSIONAL LICENSE LAW FOR ANY PERSON TO ALTER THIS DRAWING IN ANY WAY, UNLESS ACTING UNDER THE DIRECTION OF A LICENSED PROFESSIONAL ENGINEER/ARCHITECT AS APPLICABLE. THE ALTERING ENGINEER/ARCHITECT SHALL AFFIX HIS/HER SEAL AND THE NOTATION "ALTERED BY" FOLLOWED BY HIS/HER SIGNATURE AND DATE OF ALTERATION.

DESIGNED	J.L.B.
DRAWN	J.T.M.
CHECKED	G.E.
APPROVED	A.E.M.



GANNETT FLEMING/CWA, a joint venture
TWO PENN PLAZA, SUITE 552
380 SEVENTH AVENUE
NEW YORK, NY 10121-0101
PRJ: 059824




347 MADISON AVENUE
NEW YORK, N.Y. 10017

HUDSON LINE C&S IMPROVEMENTS
EQUIPMENT INSTALLATIONS
MP-32 TO MP-76

CIVIL PLANS
GRADING DETAILS FOR
CP-35 LOC B

CONTRACT NUMBER		39462	
SCALE:	AS SHOWN	DATE:	11/04/2022
DRAWING NUMBER		GRD-103	
SHEET	156	OF	610

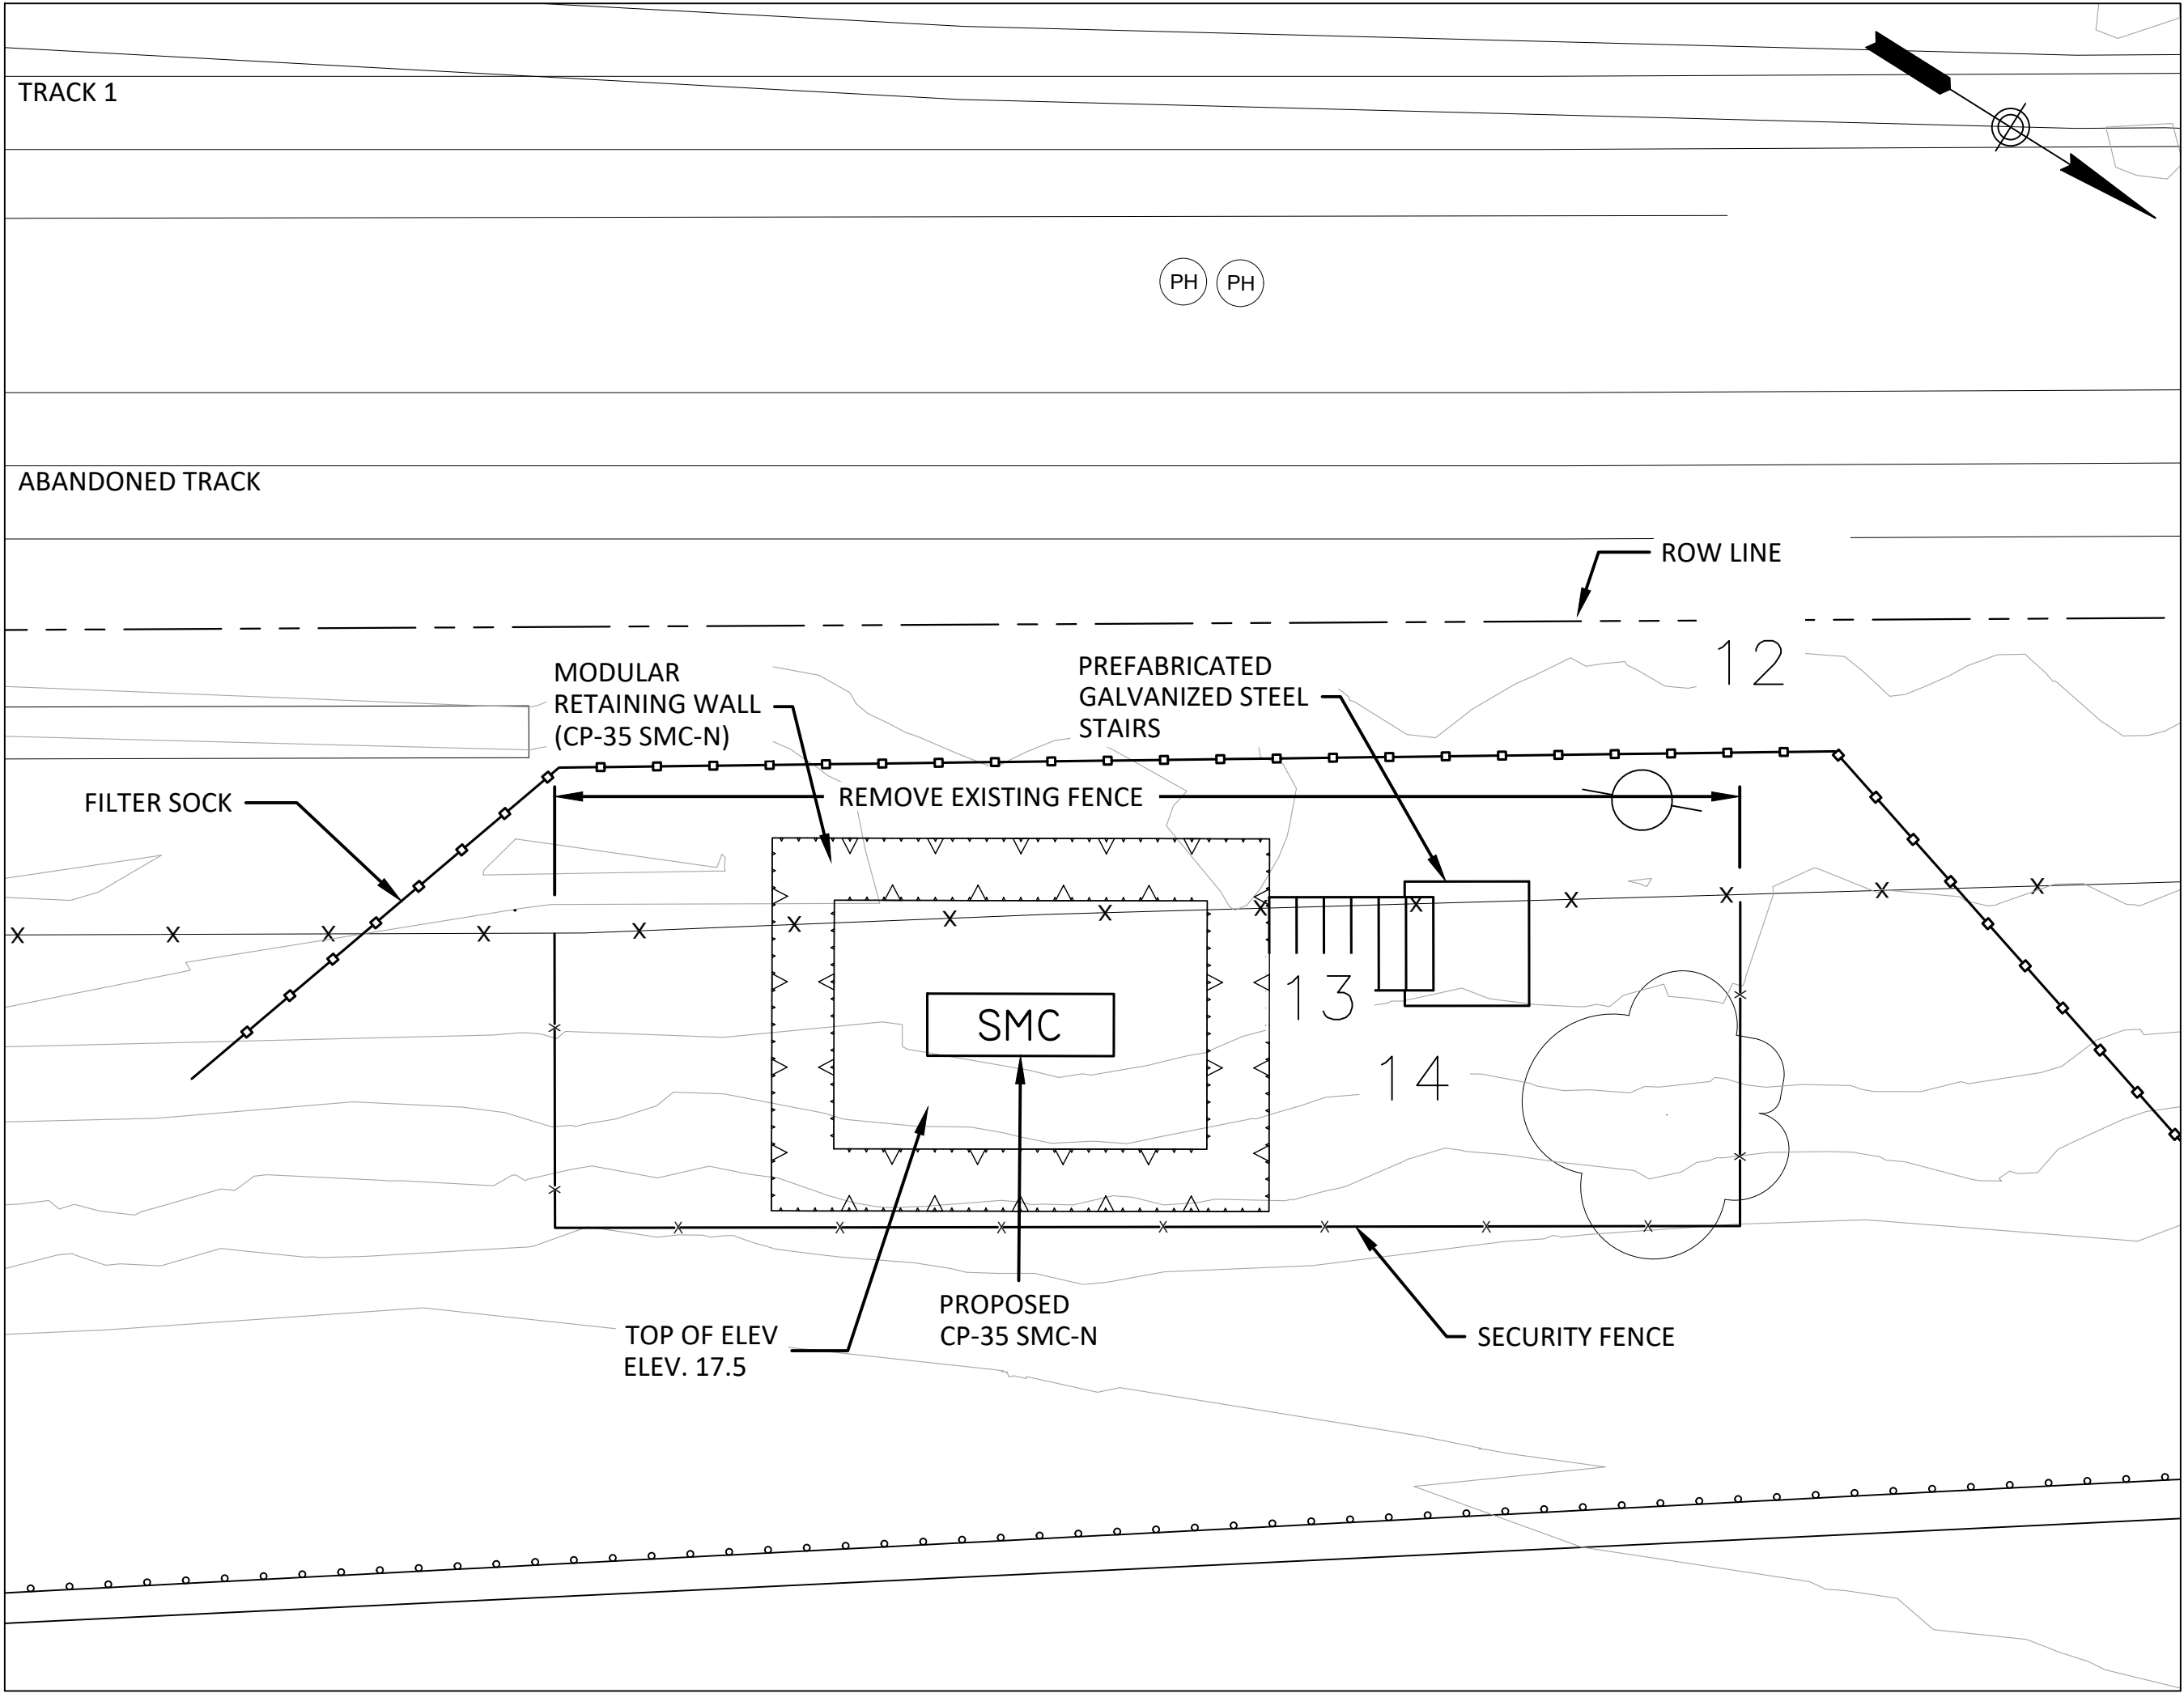


CP-35 SMC-N GRADING PLAN VIEW

SCALE: 1" = 5'-0"

5' 2.5' 0 5' 10'

1" = 5'-0"

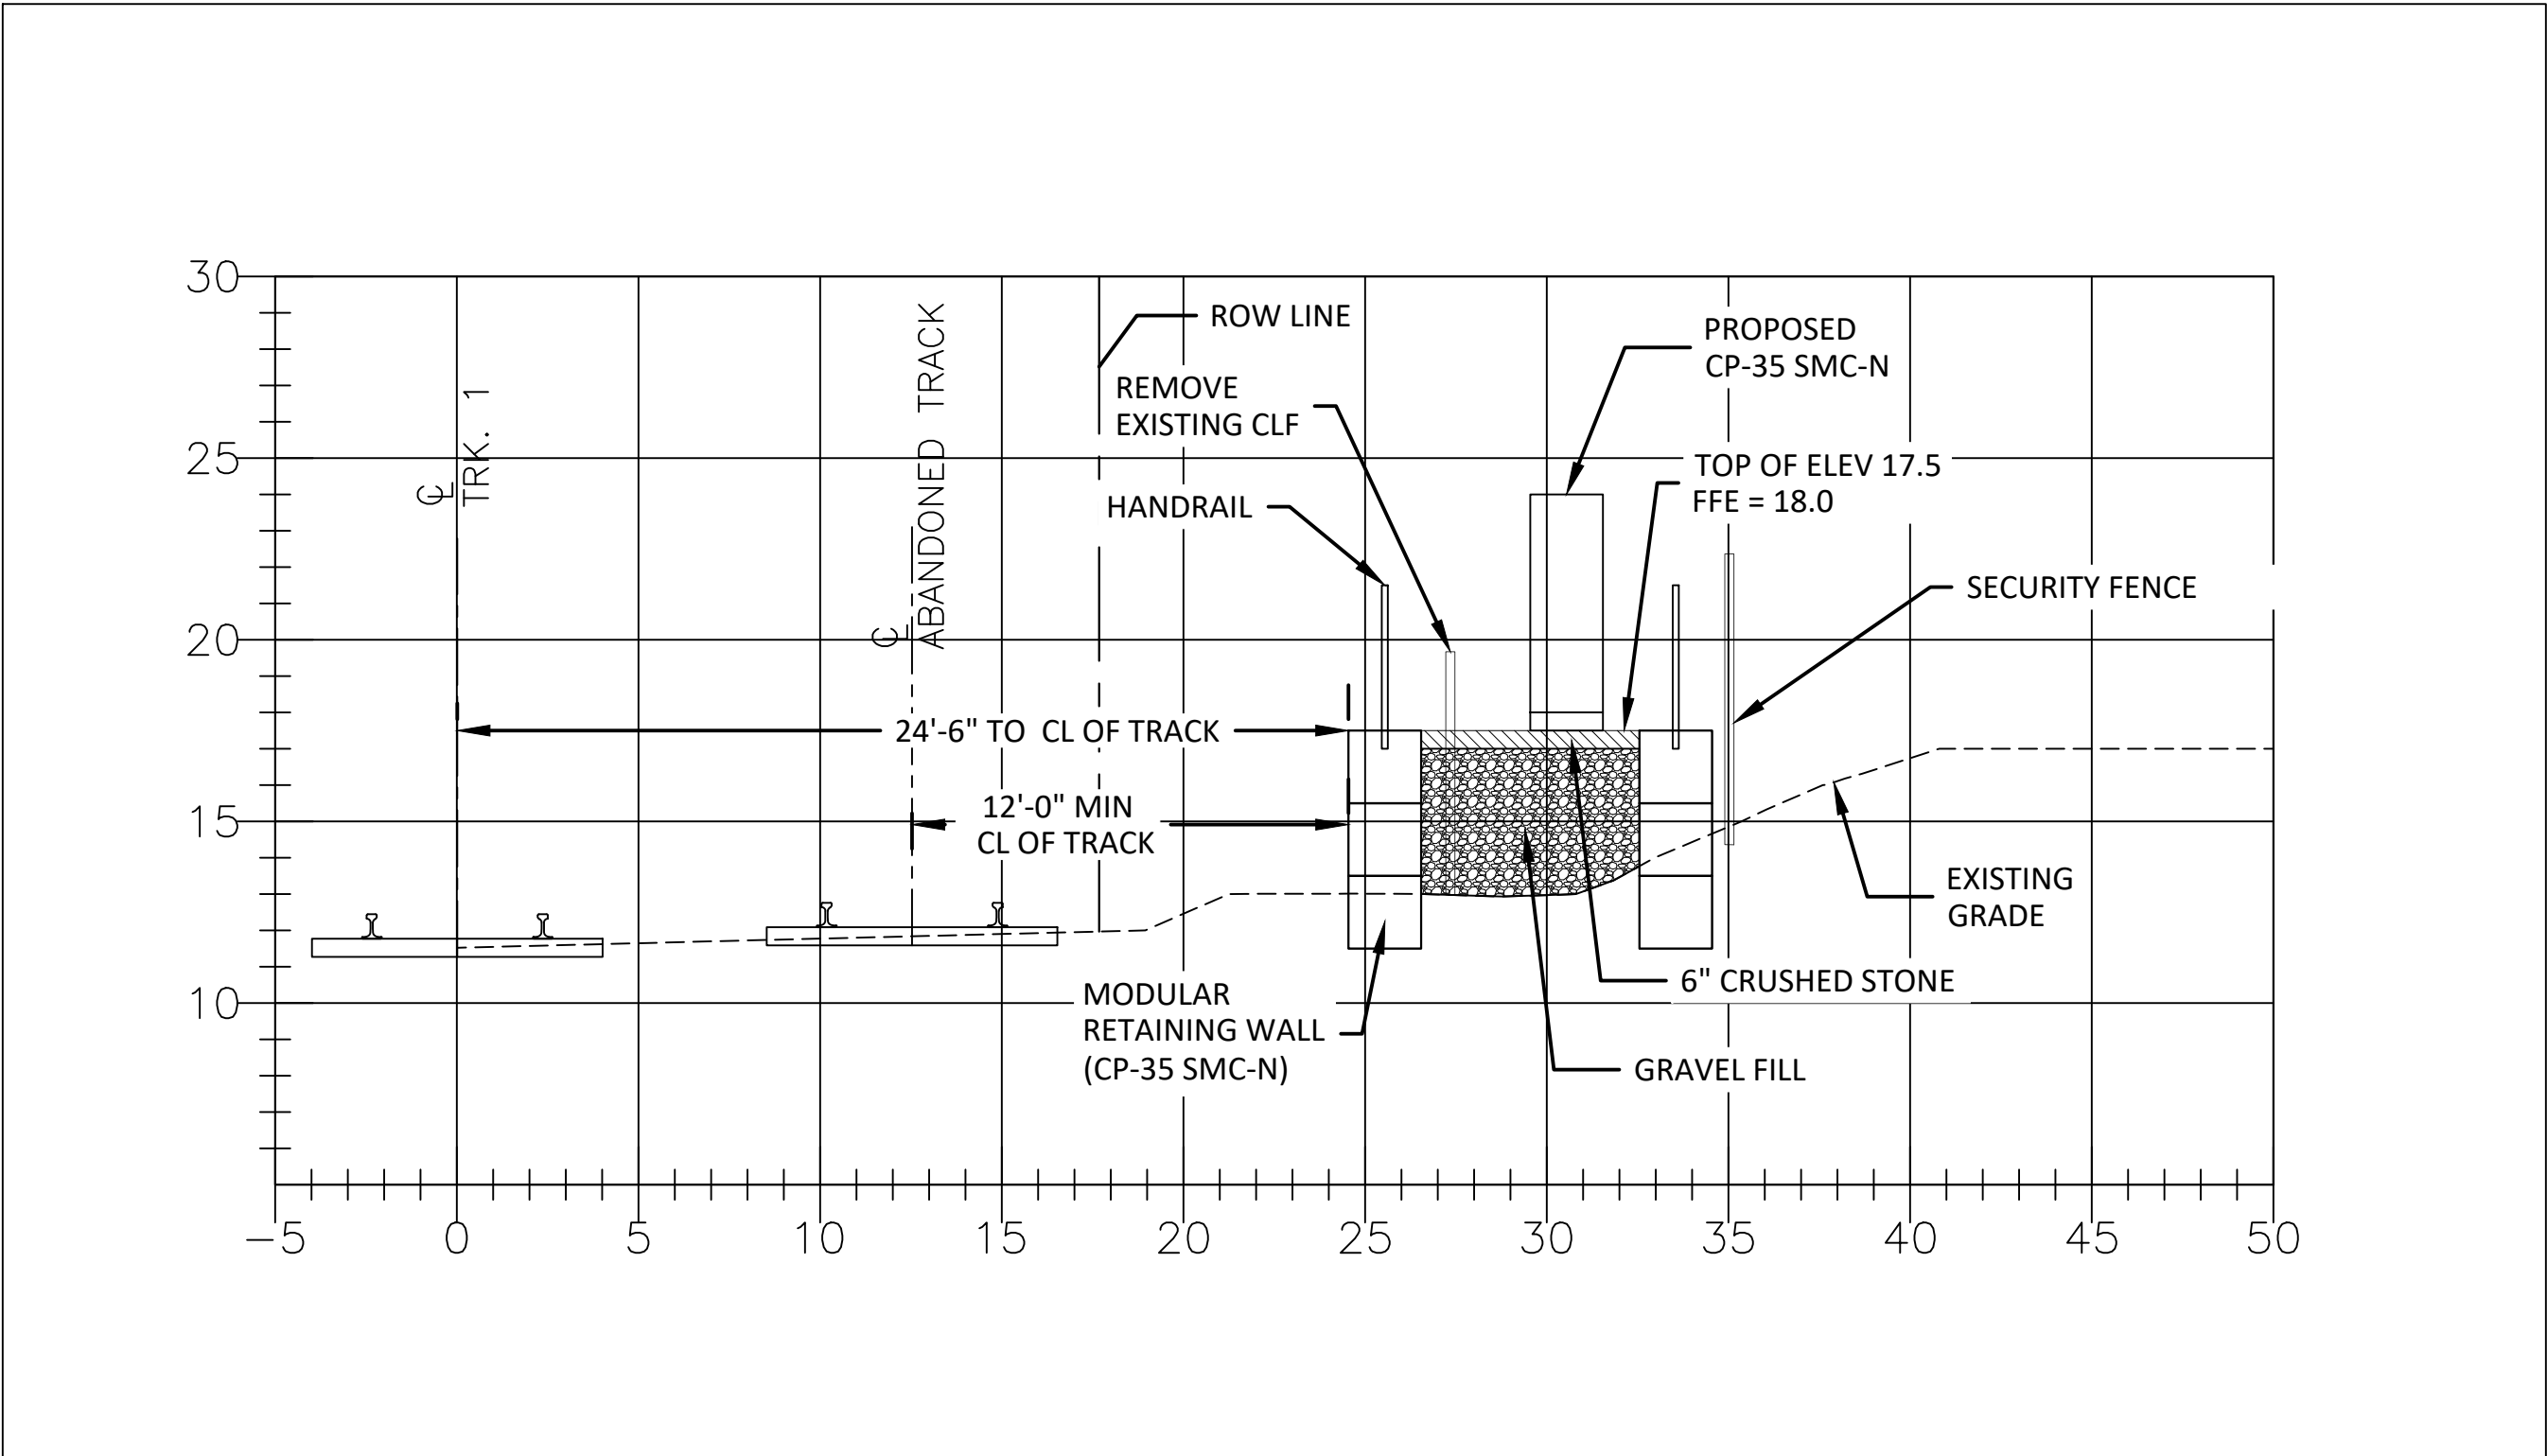

CP-35 SMC-N GRADING ELEVATION VIEW

SCALE: 1" = 5'-0"

5' 2.5' 0 5' 10'

1" = 5'-0"

95% SUBMISSION

NO.	DATE	MODIFICATION	DRAWN	CHKD.	APPRVD.	NO.	DATE	MODIFICATION	DRAWN	CHKD.	APPRVD.
REVISIONS						REVISIONS					

DISCLAIMER

IT IS A VIOLATION OF THE PROFESSIONAL LICENSE LAW FOR ANY PERSON TO ALTER THIS DRAWING IN ANY WAY, UNLESS ACTING UNDER THE DIRECTION OF A LICENSED PROFESSIONAL ENGINEER/ARCHITECT AS APPLICABLE. THE ALTERING ENGINEER/ARCHITECT SHALL AFFIX HIS/HER SEAL AND THE NOTATION "ALTERED BY" FOLLOWED BY HIS/HER SIGNATURE AND DATE OF ALTERATION.

DESIGNED	J.L.B.
DRAWN	J.T.M.
CHECKED	G.E.
APPROVED	A.E.M.

**CWA**

GANNETT FLEMING/CWA, a joint venture
TWO PENN PLAZA, SUITE 552
380 SEVENTH AVENUE
NEW YORK, NY 10121-0101
PRJ: 059824

**Metro-North Railroad**
367 MADISON AVENUE
NEW YORK, N.Y. 10017

HUDSON LINE C&S IMPROVEMENTS
EQUIPMENT INSTALLATIONS
MP-32 TO MP-76

CIVIL PLANS
GRADING DETAILS FOR
CP-35 SMC-N

CONTRACT NUMBER		39462
SCALE:	AS SHOWN	DATE: 11/04/2022
DRAWING NUMBER		GRD-104
SHEET	157	OF 610